




- NOTES
1. BETWEEN POINT OF ENTRY AND BFP, THE PIPE MUST STENCILED "FEED TO CHECK VALVE ASSEMBLY DO NOT TAP OR CONNECT TO THIS LINE" AT 5' INTERVALS AND AT ALL WALL AND FLOOR PENETRATIONS.
 2. SIZE OF LETTERS: 1/2" SIZE OF THE PIPE, COLOR: WHITE- BACKGROUND: GREEN
 3. BFP MUST HAVE SIDE TO WALL CLEARANCE =12" CLEARANCE TO OPEN AREA=30"
 4. CONTRACTOR SHALL TEST THE OPERATION OF THE BACKFLOW PREVENTER BY A STATE APPROVED TESTER.
 5. INSTALLATION TO BE INSPECTED BY A PE OR RA AND CERTIFIED TO BE IN COMPLIANCE WITH THE APPROVED PLANS.
 6. SUBMIT TO C.C.C.U. A REPORT FORM GEN 215B CERTIFYING INSTALLATION.
 7. FIRE SERVICE CLASS-2(AWW-M-14)

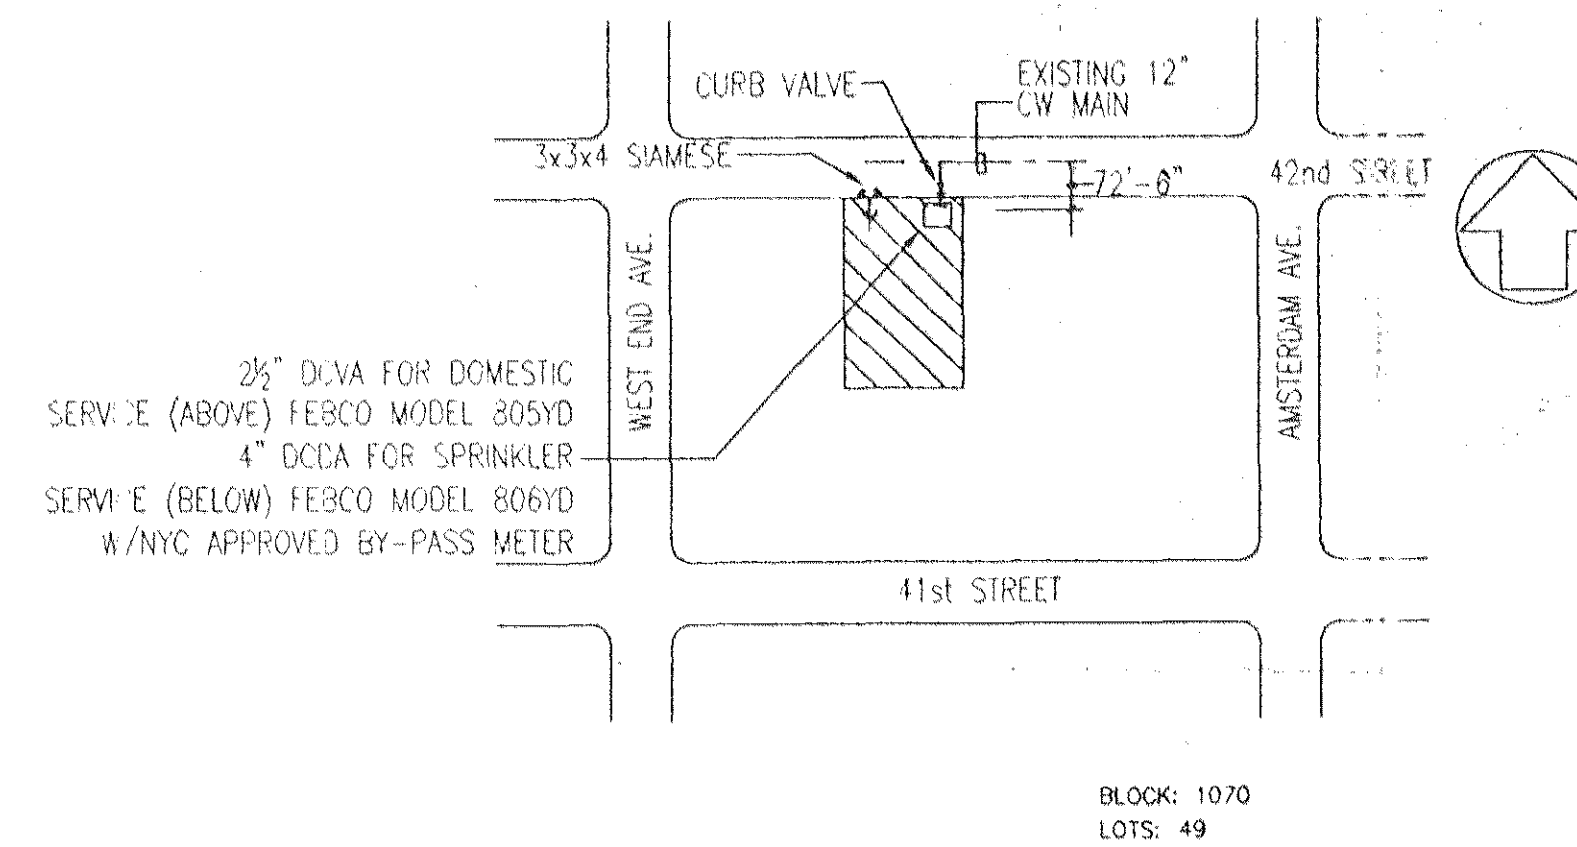

KEY PLAN

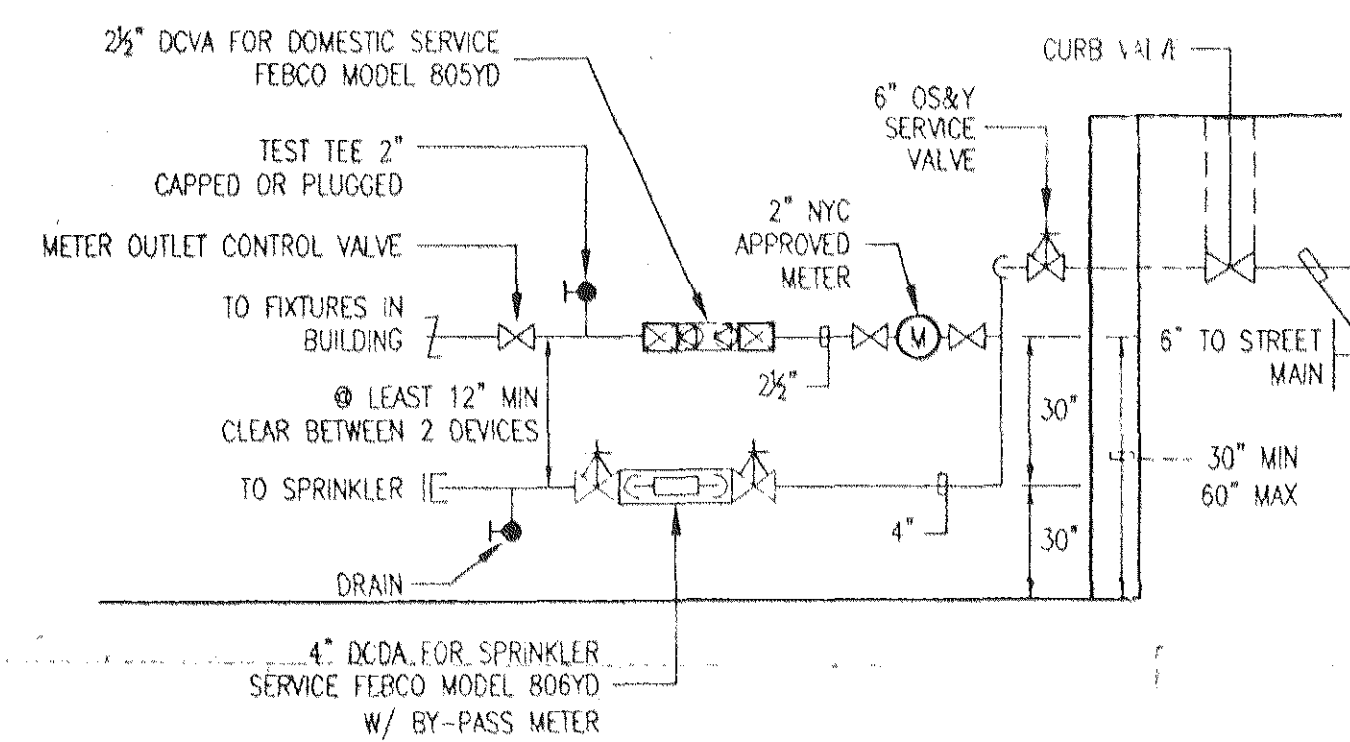

ELEVATION "A" - "A"

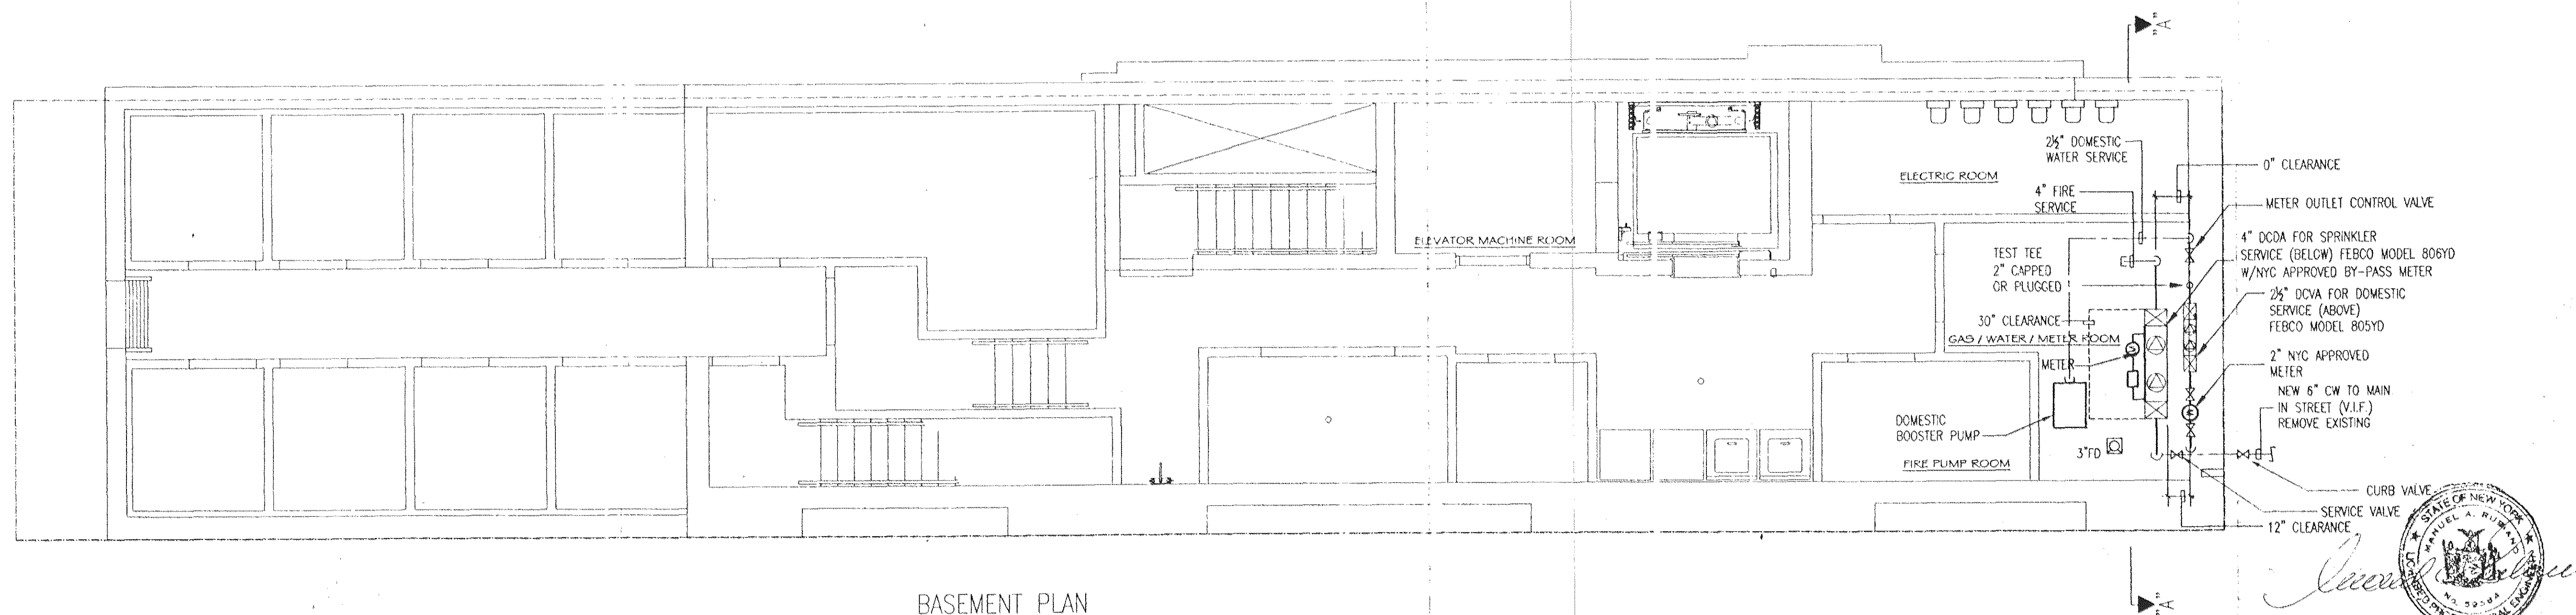

BASEMENT PLAN

Copyright 2006 Brian E. Boyle AIA
All Rights Reserved
Plans, Drawings, Specifications, Designs, Notes, and/or Details, both in print and electronic form, are the property of Brian E. Boyle AIA. They shall not be used, copied, printed, reproduced, altered or otherwise used without the prior written permission of Brian E. Boyle AIA.

Brian E. Boyle A.I.A.
73 Spring Street 6th Fl.
New York, NY 10002
212.334.7402
Fax: 212.334.6112

APPROVED
NYC DEP. Office of Design Control Unit
Project: **Backflow Preventer** Date: **10/10/06**
By: **Frank J. J. J.**
NYC Connection Control Unit

Approval by Bureau of Customer and Conservation Services required

General Notes

NOTE:

RECEIVED
DEC 19 2006
BFI CONSTRUCTION

ISSUED FOR FILING		10.10.06
ISSUED/REVISION		10.10.06
No.	Revision/Issue	Date
The Deuce 534 West 42nd Street New York NY 10036		
PLUMBING PLAN BACKFLOW PREVENTOR INSTALLATION		
Scale	1/4" = 1'-0"	Sheet No.
Date	10-10-2006	BFP-100
Drawn By		

MAR
M. A. RUBIANO, P.C.
CONSULTING ENGINEERS
45 JOHN STREET, SUITE 903
N.Y., N.Y. 10038 (212) 732-7842