


2-9-10
 2-8 #2
 2-16
 EXT-2-2


- LEGEND**
- OUTLET W/ DEDICATED CIRCUIT @ 12' A.F.F.
 - SINGLE OUTLET @ 12' A.F.F., U.O.N.
 - DUPLEX OUTLET @ 12' A.F.F., U.O.N.
 - GROUND FAULT INTERRUPTER OUTLET @ 42' A.F.F., U.O.N.
 - DUPLEX OUTLET HALF HOT @ 12' A.F.F., U.O.N.
 - 220 VOLT OUTLET @ 12' A.F.F., U.O.N.
 - QUAD OUTLET @ 12' A.F.F., U.O.N.
 - FLOOR DUPLEX OUTLET
 - FLOOR TELEPHONE JACK
 - WALL SWITCH @ 36" A.F.F.
 - THREE WAY WALL SWITCH @ 36" A.F.F.
 - FOUR WAY WALL SWITCH @ 36" A.F.F.
 - JAMB SWITCH @ 5'0" A.F.F.
 - KEYED SWITCH
 - SECURITY CARD READER
 - THERMOSTAT @ 5'0" A.F.F.
 - TELEPHONE / DATA JACK @ 12' A.F.F.
 - HOUSE PHONE INTERCOM @ 5'0" A.F.F.
 - SECURITY CAMERA
 - HANDICAP DOOR ACTUATOR
 - CABLE JACK @ 12' A.F.F.
 - STRIP LIGHT
 - WALL SCONCE @ 5'0" A.F.F.
 - JUNCTION BOX
 - SPRINKLER
 - 18" DIA. SURFACE MOUNTED FLUORESCENT LIGHT FIXTURE
 - 18" DIA. SURFACE MOUNTED FLUORESCENT W/ EMERGENCY BATTERY PACK
 - RECESSED LIGHT FIXTURE
 - DIRECTIONAL LIGHT FIXTURE
 - SMOKE DETECTOR
 - CARBON MONOXIDE DETECTOR
 - EXIT LIGHT
 - EMERGENCY BATTERY POWERED LIGHT
 - RETURN AIR GRILLE OR EXHAUST
 - AIR DIFFUSER
 - 22" DIA. SURFACE MOUNTED FLUORESCENT LIGHT FIXTURE
 - SURFACE MOUNTED FLUORESCENT LIGHT FIXTURE @ 8'0" A.F.F. UNLESS OTHERWISE NOTED
 - ACCESS DOOR

- 3 REVISION ISSUED FOR CONSTRUCTION 12.01.06
 2 REVISION ISSUED FOR CONSTRUCTION 11.17.06
 1 REVISED ISSUED FOR PRICING 08.09.06
 ISSUED FOR PRICING 07.26.06

No.	Revision/Issue	Date
The Deuce 534 W. 42nd Street New York NY 10036		
ELECTRICAL & LIGHTING PLAN FIRST FLOOR		
Scale	1/4" = 1'-0"	Sheet No.
Date	07.26.06	E-203
Drawn By	CCC	

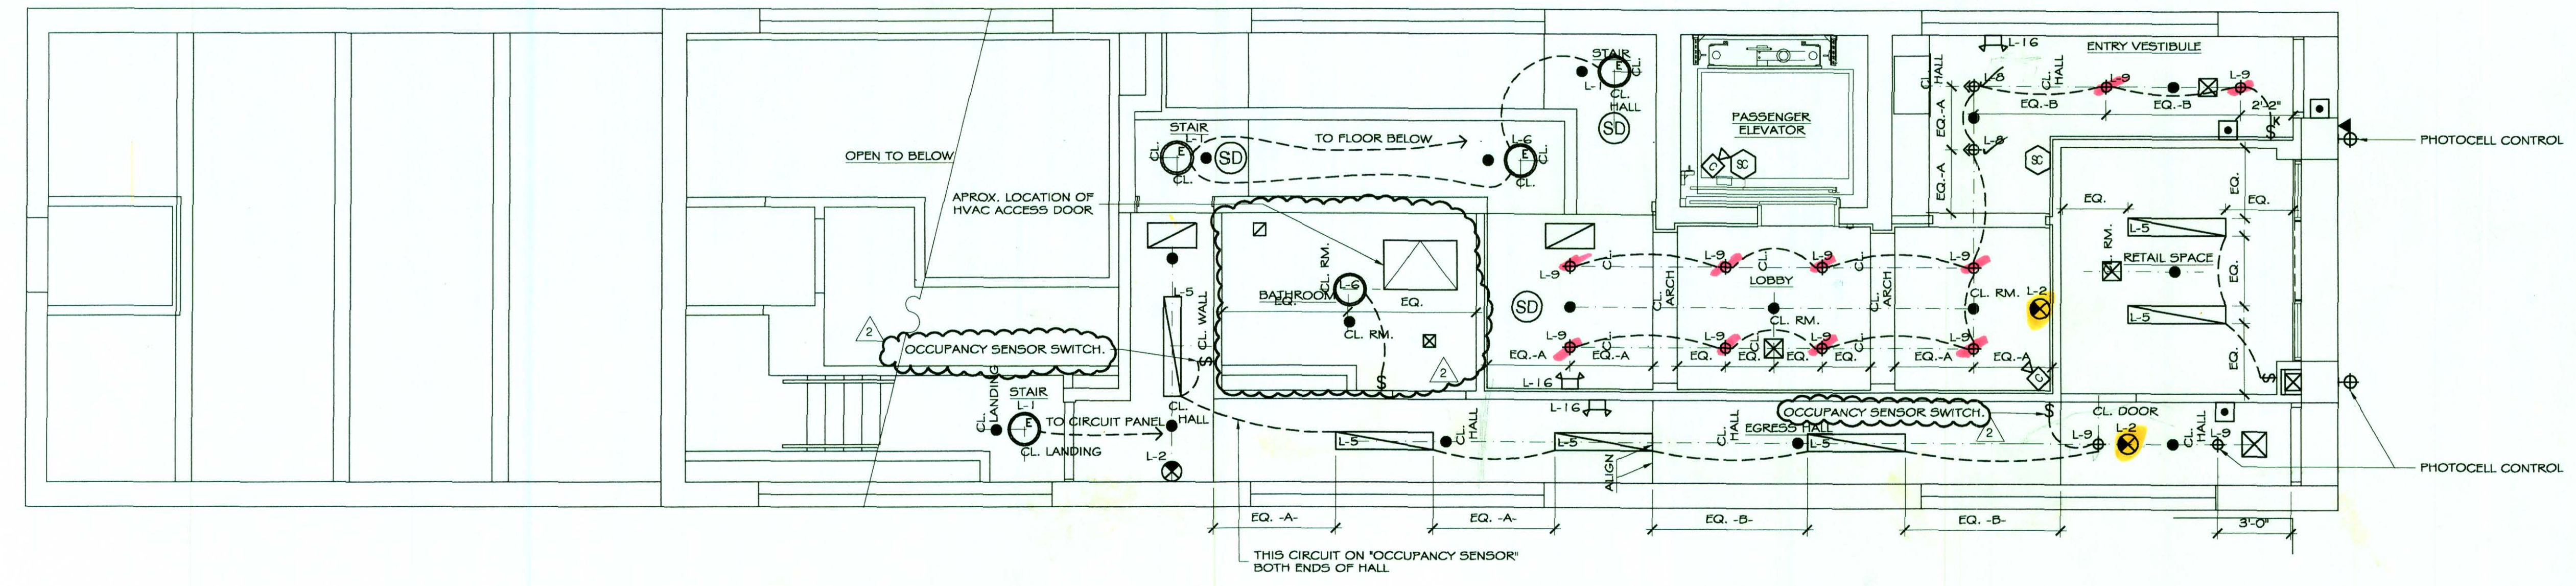

LIGHTING PLAN
 1/4" = 1'-0"

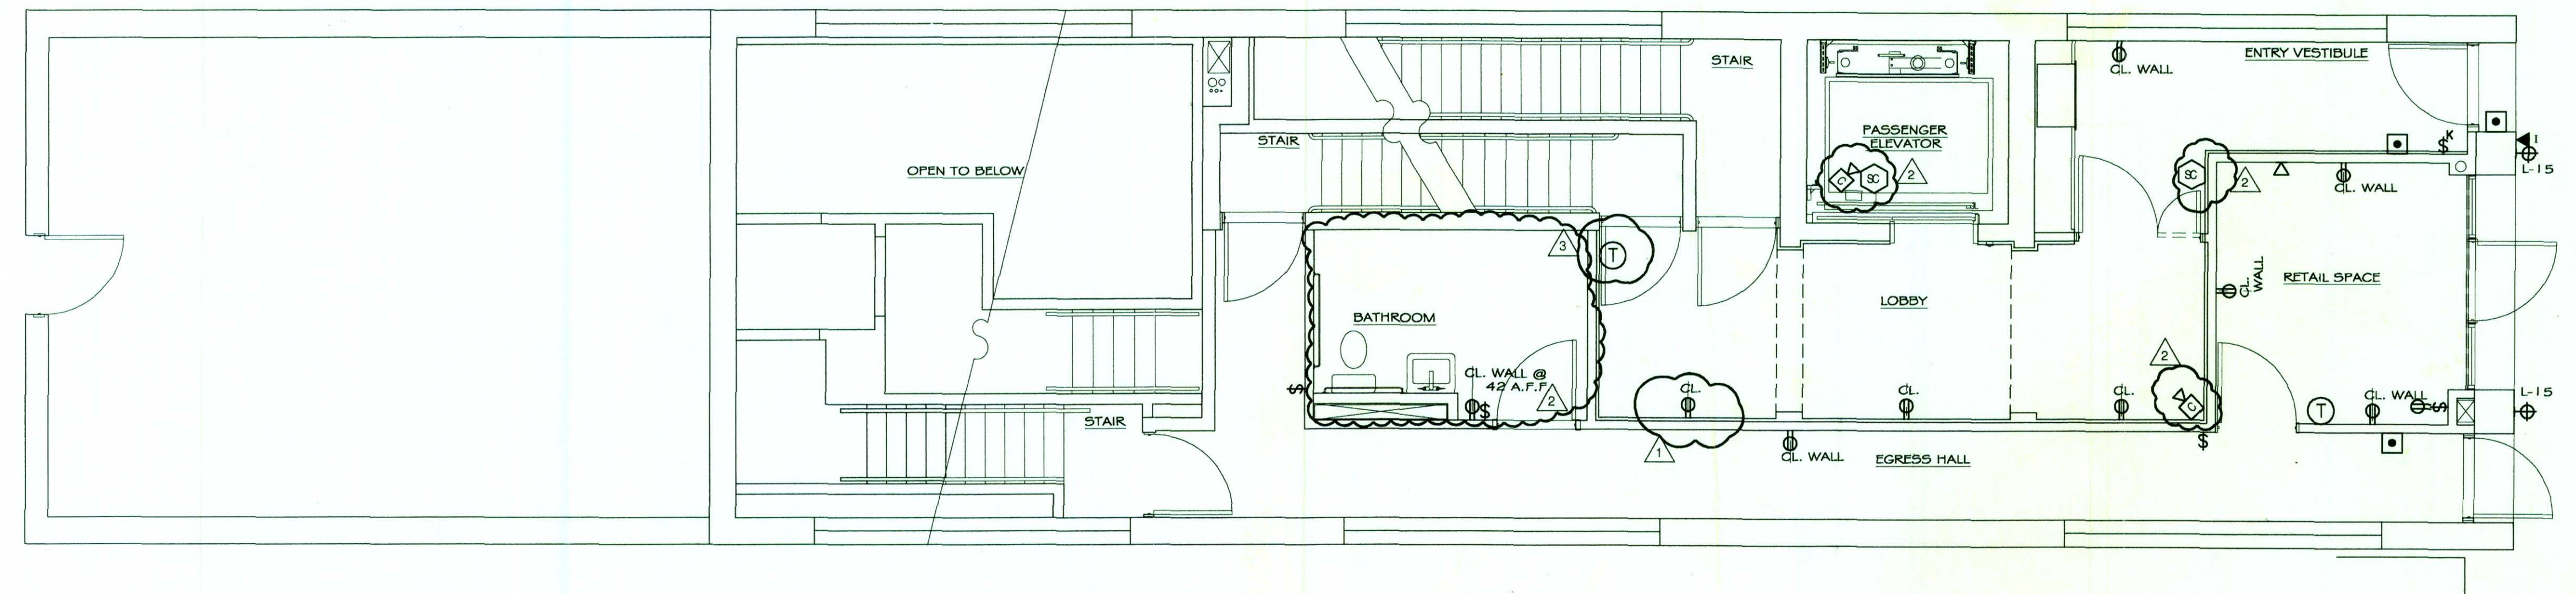

ELECTRICAL PLAN
 1/4" = 1'-0"