

Brian E. Boyle A.I.A.

75 Spring Street 6th Flr
New York, NY 10002
212.334.7402
Fax 212.334.6112

LEGEND

- OUTLET W/ DEDICATED CIRCUIT @ 12" A.F.F.
- SINGLE OUTLET @ 12" A.F.F., U.O.N.
- DUPLEX OUTLET @ 12" A.F.F., U.O.N.
- GROUND FAULT INTERRUPTER OUTLET @ 42" A.F.F., U.O.N.
- DUPLEX OUTLET HALF HOT @ 12" A.F.F., U.O.N.
- 220 VOLT OUTLET @ 12" A.F.F., U.O.N.
- QUAD OUTLET @ 12" A.F.F., U.O.N.
- FLOOR DUPLEX OUTLET
- FLOOR TELEPHONE JACK
- WALL SWITCH @ 36" A.F.F.
- THREE WAY WALL SWITCH @ 36" A.F.F.
- FOUR WAY WALL SWITCH @ 36" A.F.F.
- JAMB SWITCH @ 6" A.F.F.
- KEYED SWITCH
- SECURITY CARD READER
- THERMOSTAT @ 5" A.F.F.
- TELEPHONE / DATA JACK @ 12" A.F.F.
- HOUSE PHONE INTERCOM @ 5" A.F.F.
- SECURITY CAMERA
- HANDICAP DOOR ACTUATOR
- CABLE JACK @ 12" A.F.F.
- STRIP LIGHT
- WALL SCONCE @ 5" A.F.F.
- JUNCTION BOX
- SPRINKLER
- 18" DIA. SURFACE MOUNTED FLUORESCENT LIGHT FIXTURE
- 18" DIA. SURFACE MOUNTED FLUORESCENT W/ EMERGENCY BATTERY PACK
- RECESSED LIGHT FIXTURE
- DIRECTIONAL LIGHT FIXTURE
- SMOKE DETECTOR
- CARBON MONOXIDE DETECTOR
- EXIT LIGHT
- EMERGENCY BATTERY POWERED LIGHT
- RETURN AIR GRILLE OR EXHAUST
- AIR DIFFUSER
- 22" DIA. SURFACE MOUNTED FLUORESCENT LIGHT FIXTURE
- SURFACE MOUNTED FLUORESCENT LIGHT FIXTURE @ 8" A.F.F.
UNLESS OTHERWISE NOTED
- ACCESS DOOR
- RETURN AIR GRILLE

- 5 REVISION ISSUED FOR CONSTRUCTION 10/31/08
- 4 REVISION ISSUED FOR CONSTRUCTION 09/20/07
- 3 REVISION ISSUED FOR CONSTRUCTION 02/01/07
- ISSUED FOR CONSTRUCTION 12/01/06
- 2 ISSUED FOR CONSTRUCTION 11/17/06
- ISSUED FOR PRICING 07/26/06

No.	Revision/Issue	Date
-----	----------------	------


The Deuce
534 W.42nd Street
New York NY 10036

ELECTRICAL &
LIGHTING PLAN
NINTH FLOOR

Scale 1/4" = 1'-0"
Date 07.26.06
Drawn By CCC


Sheet No.

E-207

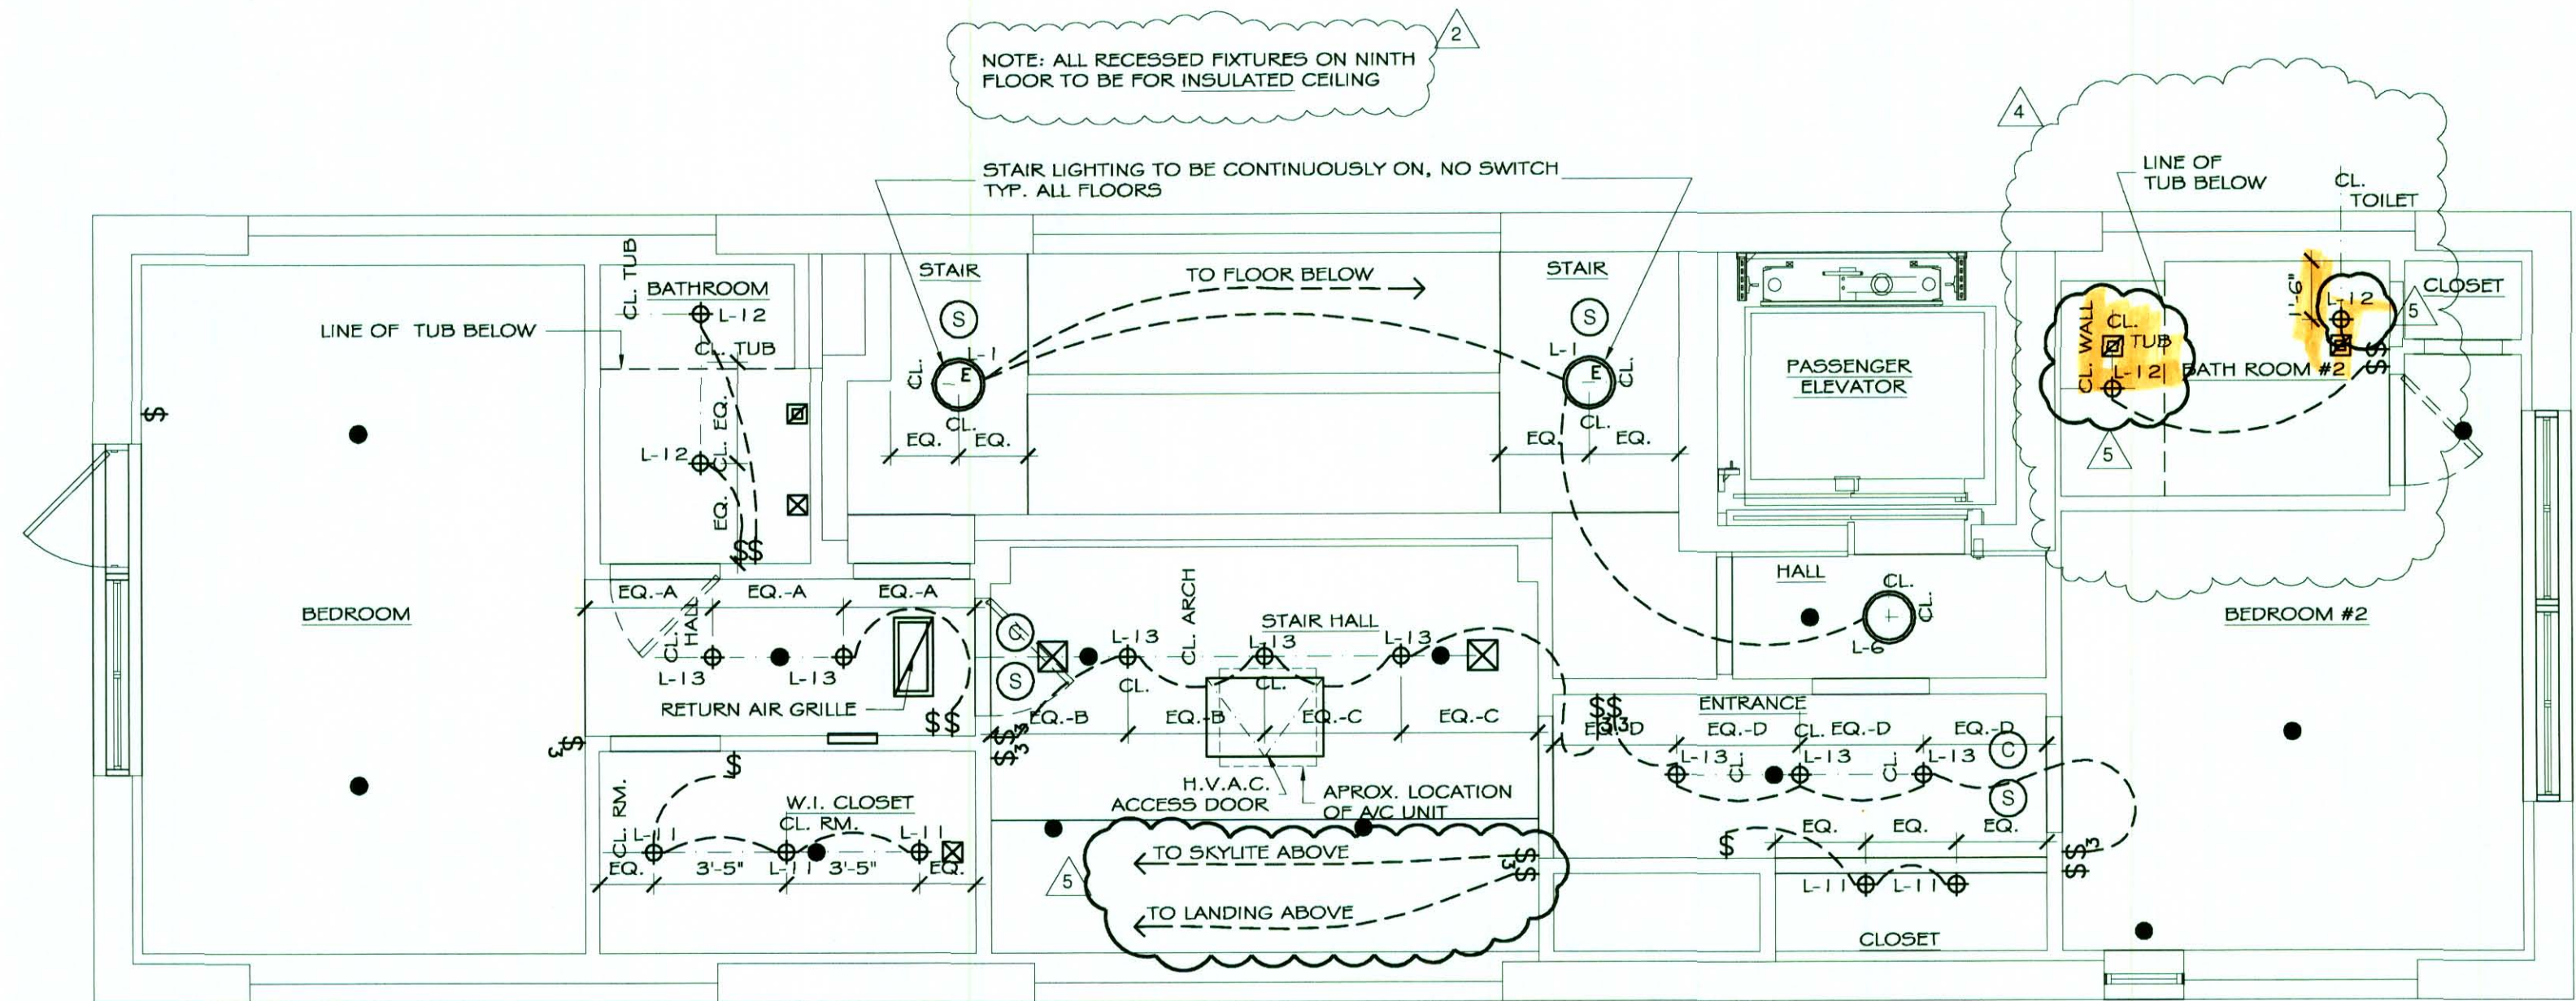

LIGHTING PLAN

1/4" = 1'-0"

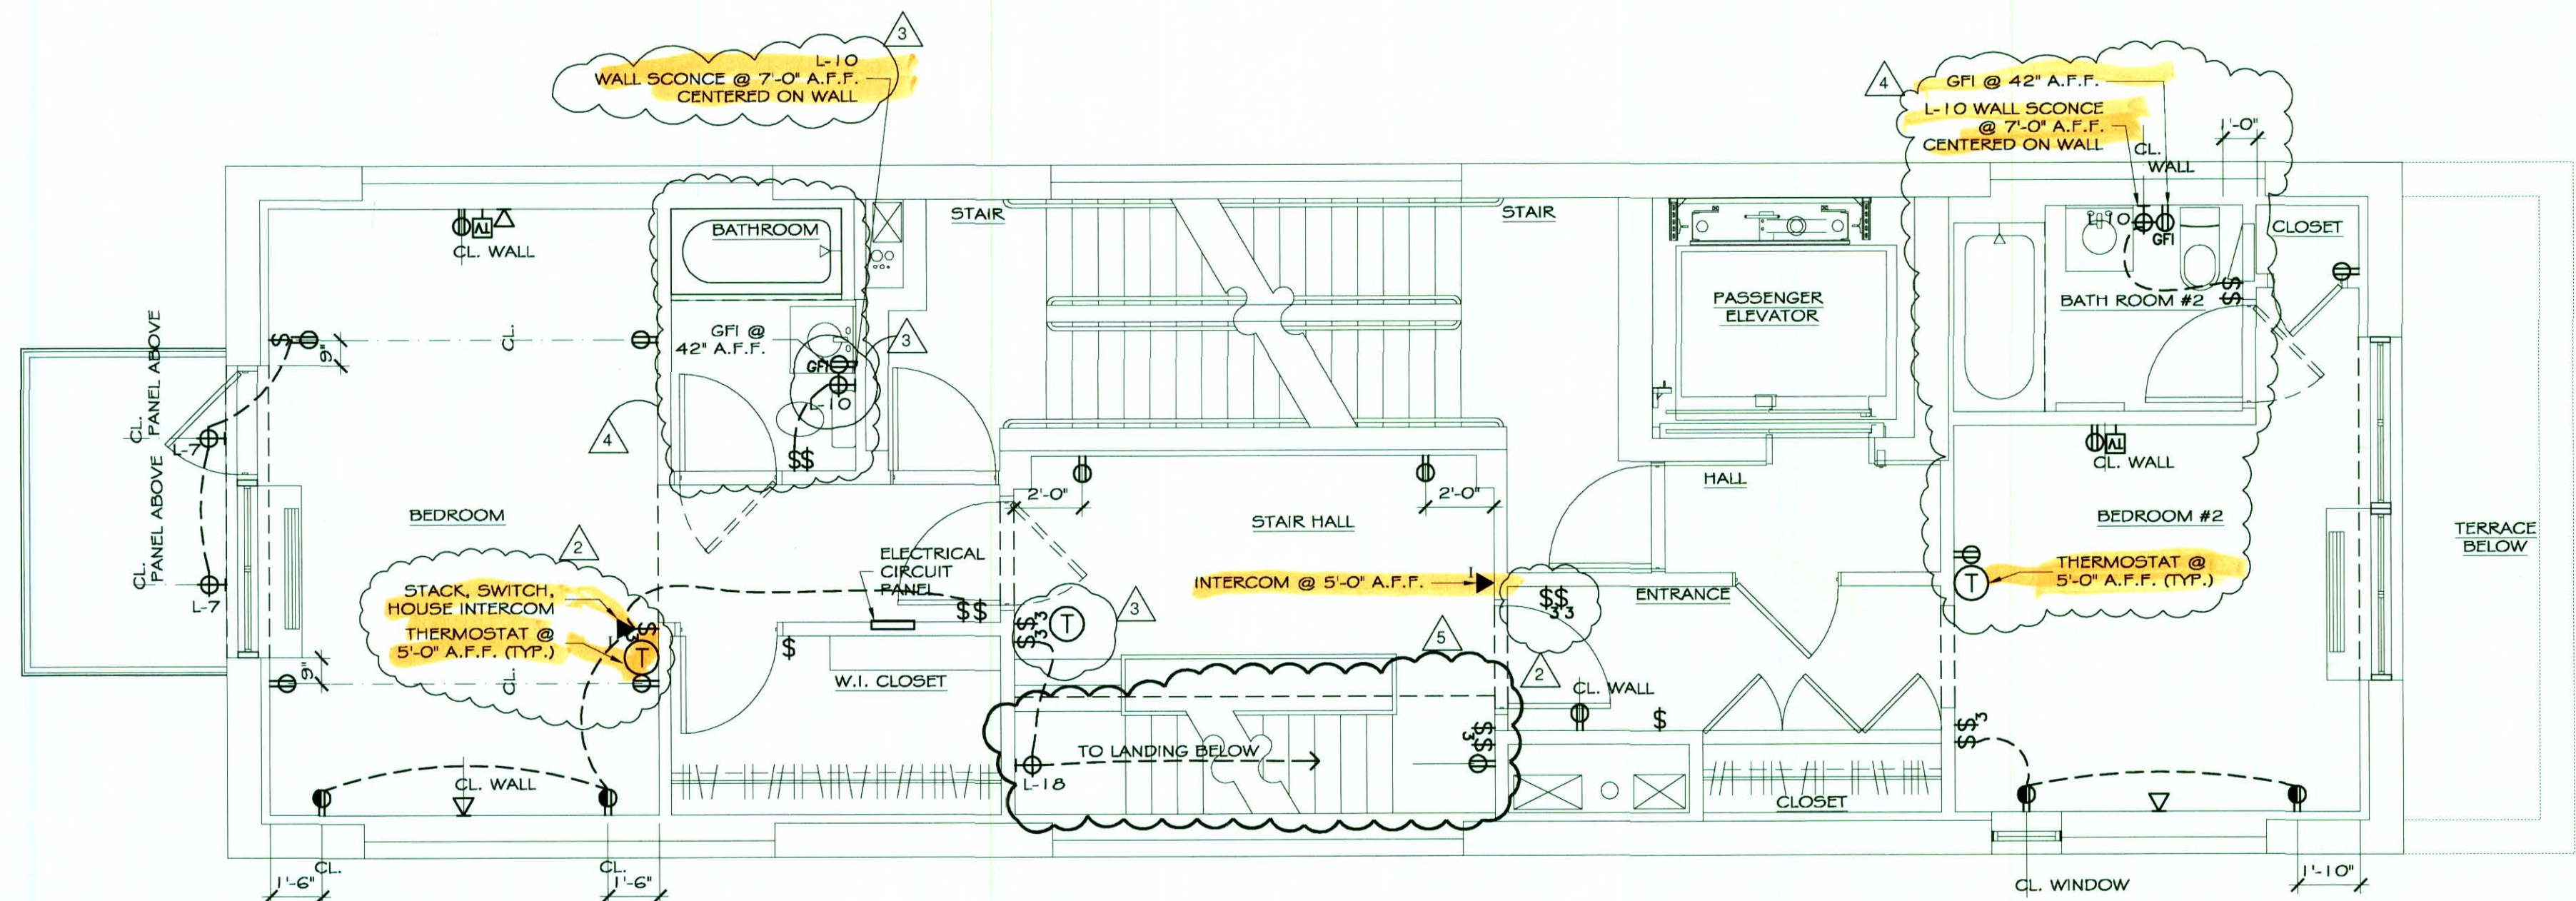

ELECTRICAL PLAN

1/4" = 1'-0"