



Brian E. Boyle A.I.A.

75 Spring Street 6th Flr
 New York, NY 10002
 212.334.7408
 Fax 212.334.6112

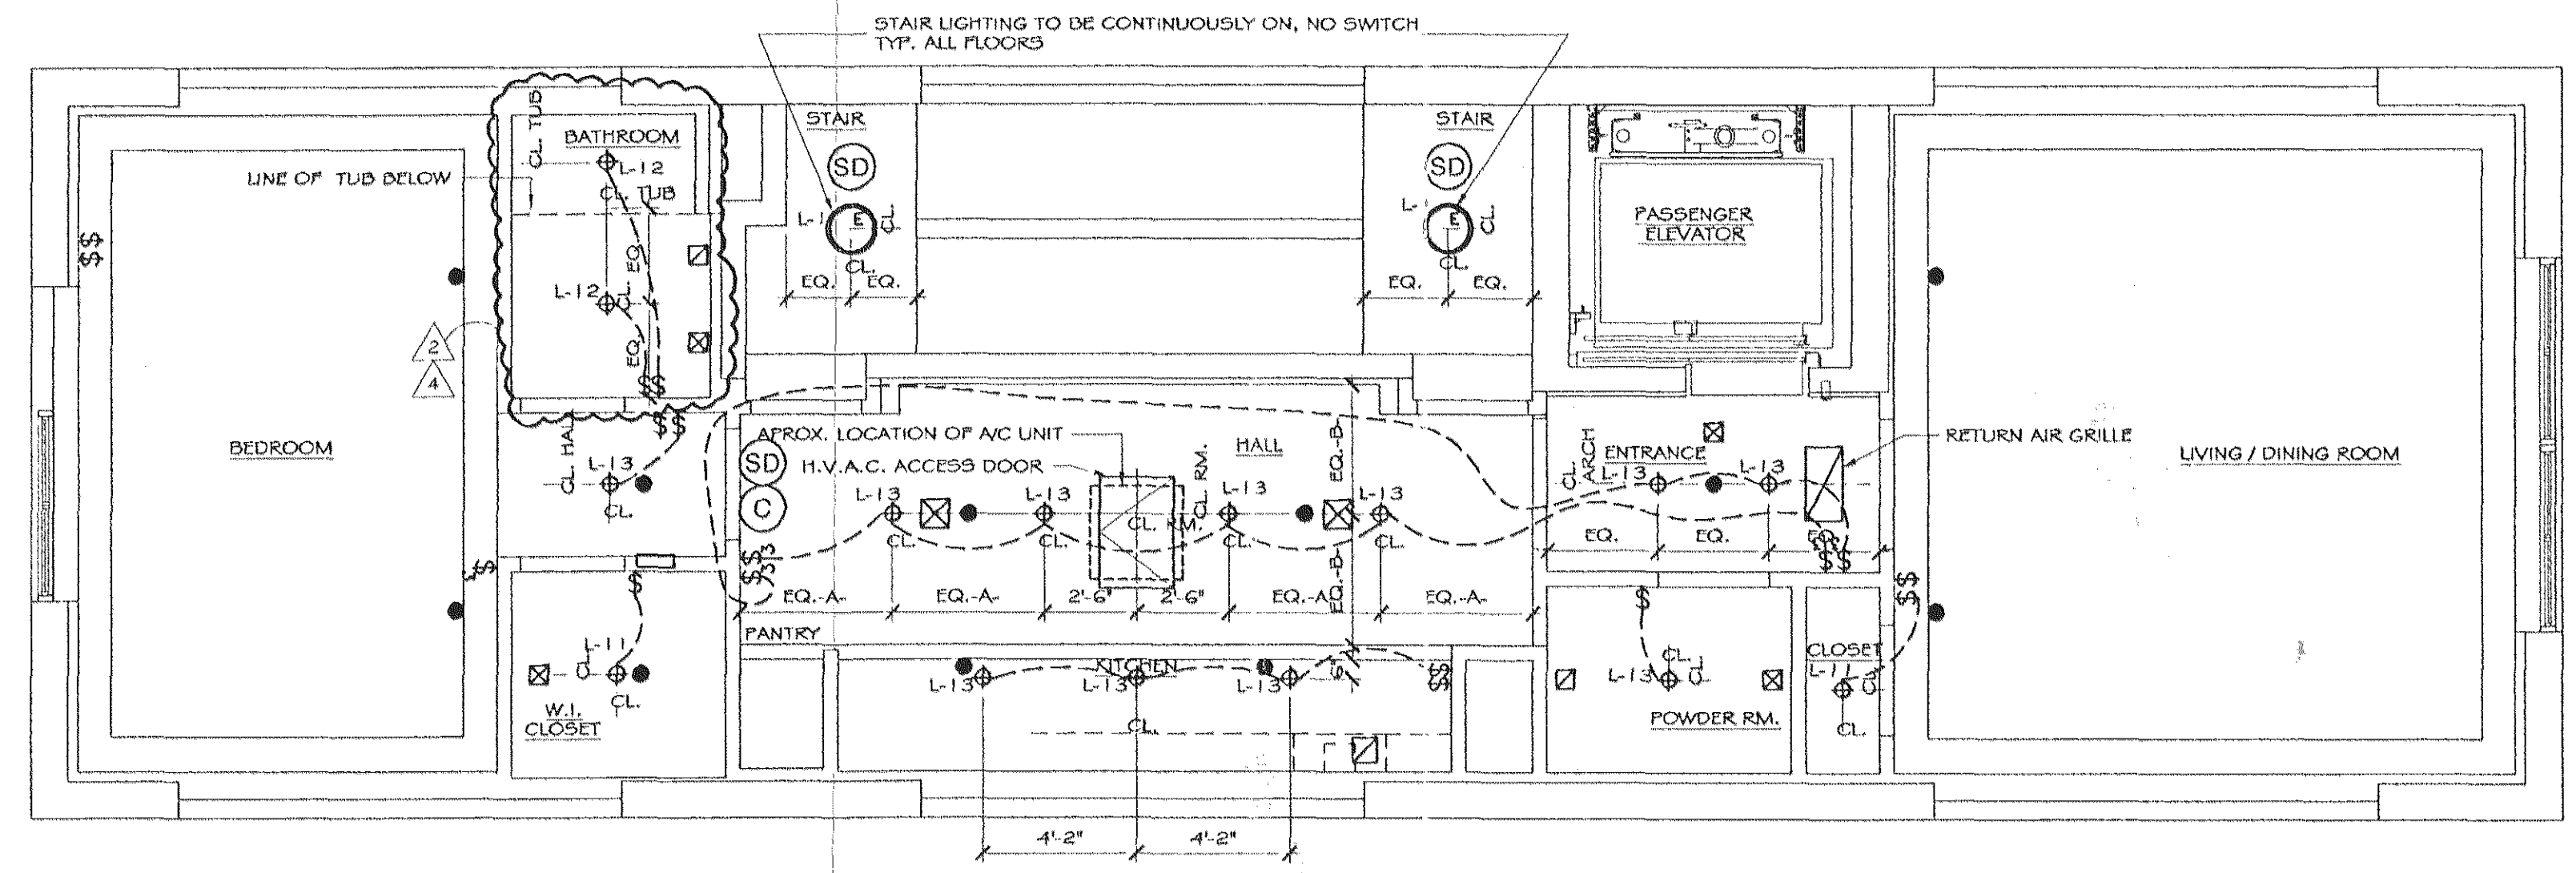

LIGHTING PLAN
 1/4" = 1'-0"

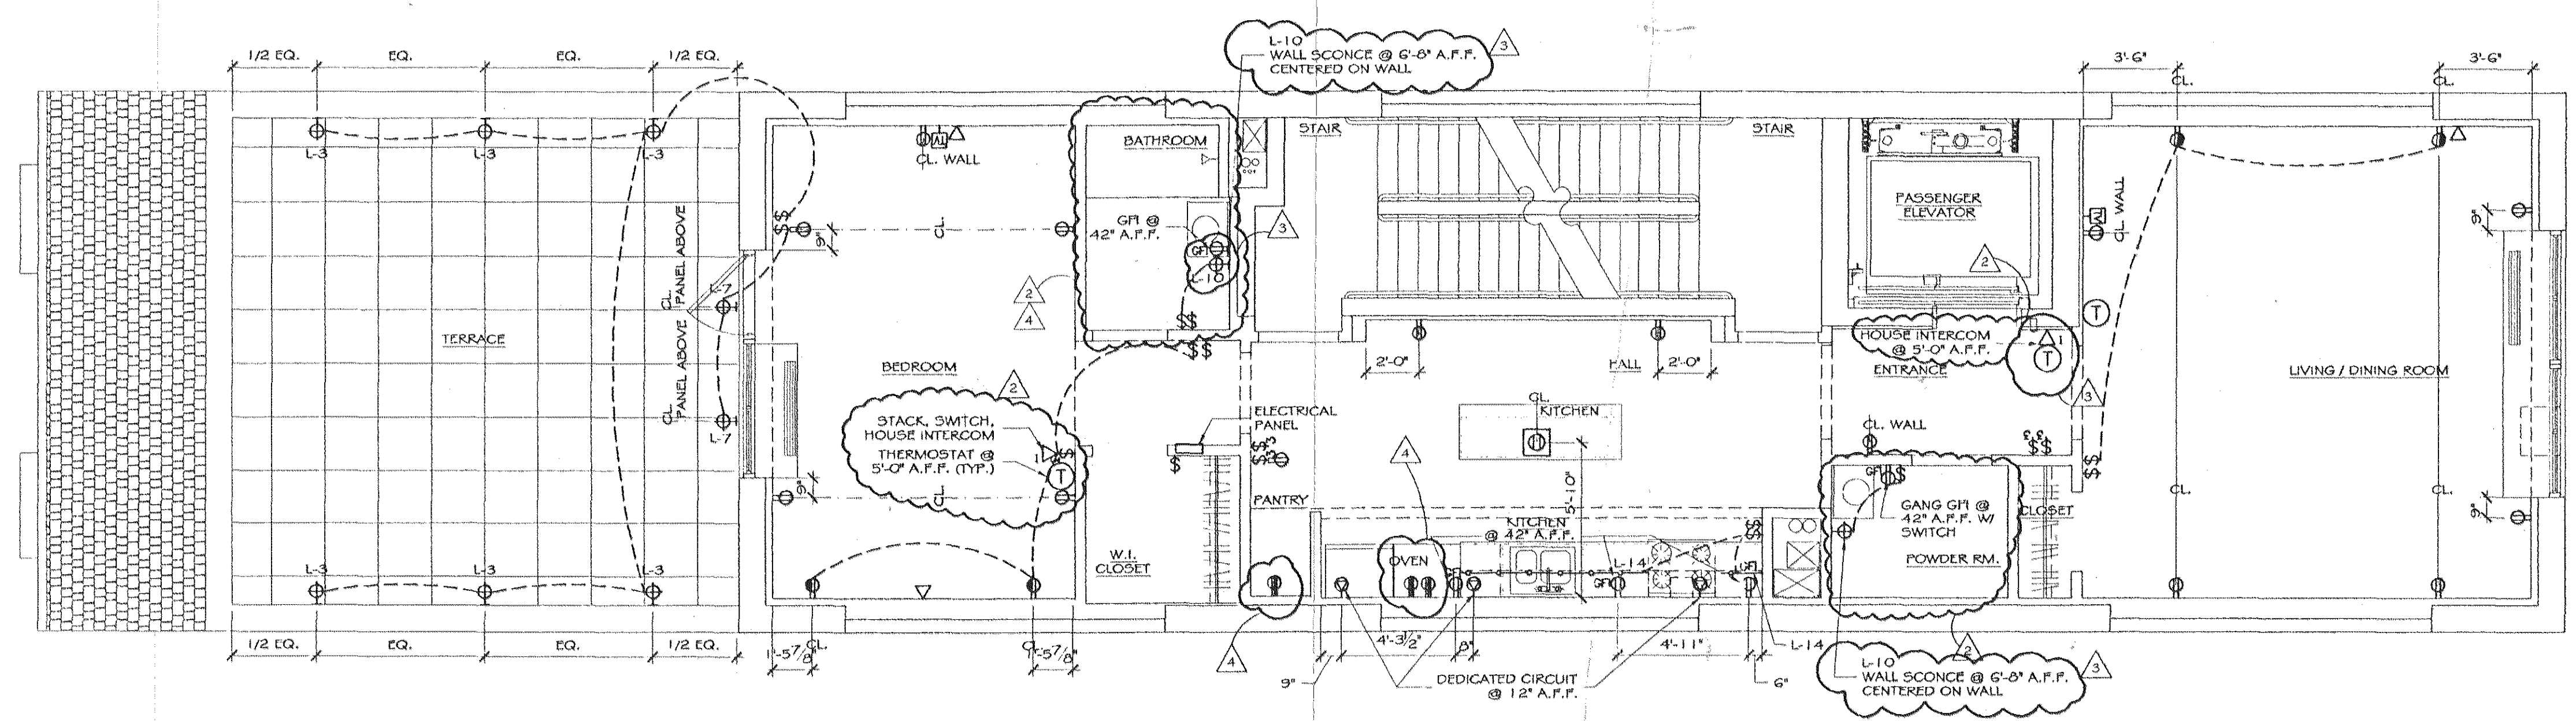

ELECTRICAL PLAN
 1/4" = 1'-0"

- LEGEND
- OUTLET W/ DEDICATED CIRCUIT @ 12" A.F.F.
 - SINGLE OUTLET @ 12" A.F.F., U.O.N.
 - DUPLEX OUTLET @ 12" A.F.F., U.O.N.
 - GROUND FAULT INTERRUPTER OUTLET @ 40" A.F.F., U.O.N.
 - DUPLEX OUTLET HALF HOT @ 12" A.F.F., U.O.N.
 - 220 VOLT OUTLET @ 12" A.F.F., U.O.N.
 - QUAD OUTLET @ 12" A.F.F., U.O.N.
 - FLOOR DUPLEX OUTLET
 - FLOOR TELEPHONE JACK
 - WALL SWITCH @ 30" A.F.F.
 - THREE WAY WALL SWITCH @ 30" A.F.F.
 - FOUR WAY WALL SWITCH @ 30" A.F.F.
 - JAMB SWITCH @ 8" A.F.F.
 - KEYSWITCH
 - SECURITY CARD READER
 - THERMOSTAT @ 9" A.F.F.
 - TELEPHONE / DATA JACK @ 12" A.F.F.
 - HOUSE PHONE INTERCOM @ 2" A.F.F.
 - SECURITY CAMERA
 - HANDICAP DOOR ACTUATOR
 - CABLE JACK @ 12" A.F.F.
 - STRIP LIGHT
 - WALL SCONCE @ 9" A.F.F.
 - JUNCTION BOX
 - SPRINKLER
 - 10" DIA. SURFACE MOUNTED FLUORESCENT LIGHT FIXTURE
 - 18" DIA. SURFACE MOUNTED FLUORESCENT W/ EMERGENCY BATTERY PACK
 - RECESSED LIGHT FIXTURE
 - DIRECTIONAL LIGHT FIXTURE
 - SMOKE DETECTOR
 - CARBON MONOXIDE DETECTOR
 - EXIT LIGHT
 - EMERGENCY BATTERY POWERED LIGHT
 - RETURN AIR GRILLE OR EXHAUST
 - AIR DIFFUSER
 - 20" DIA. SURFACE MOUNTED FLUORESCENT LIGHT FIXTURE
 - SURFACE MOUNTED FLUORESCENT LIGHT FIXTURE @ 8" A.F.F. UNLESS OTHERWISE NOTED
 - ACCESS DOOR

- 4 REVISION ISSUED FOR CONSTRUCTION 09/20/07
- 3 REVISION ISSUED FOR CONSTRUCTION 02/01/07
- REVISION ISSUED FOR CONSTRUCTION 12/01/06
- 2 ISSUED FOR CONSTRUCTION 11/17/06
- ISSUED FOR PRICING 07/26/06

No.	Revision/Issue	Date
The Deuce 534 W. 42nd Street New York NY 10036		
ELECTRICAL & LIGHTING PLAN SECOND FLOOR		
Scale	1/4" = 1'-0"	Sheet No.
Date	07.26.06	E-204
Drawn By	CCC	

RECEIVED
 SEP 21 2007
 BFI CONSTRUCTION