



Brian E. Boyle A.I.A.

75 Spring Street 6th Flr
New York, NY 10002
212.334.7402
Fax 212.334.6112

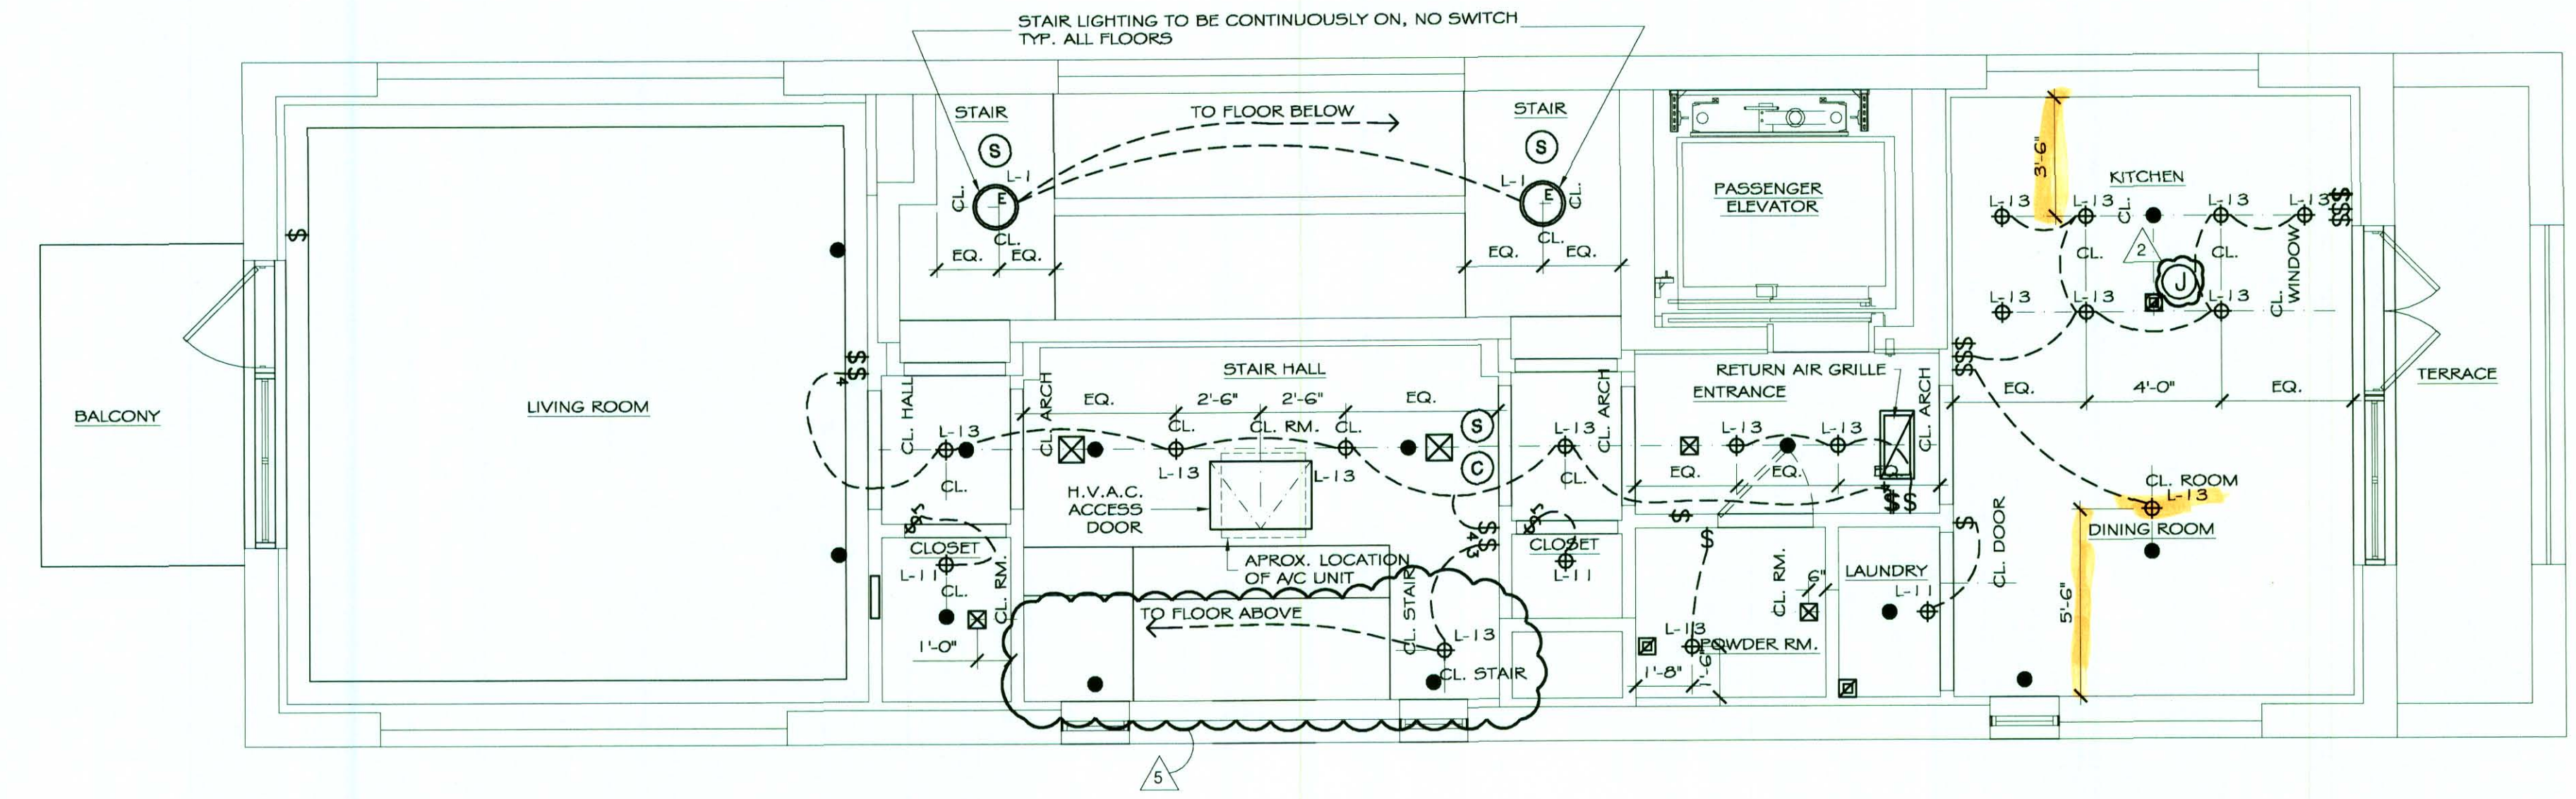

LIGHTING PLAN
1/4" = 1'-0"

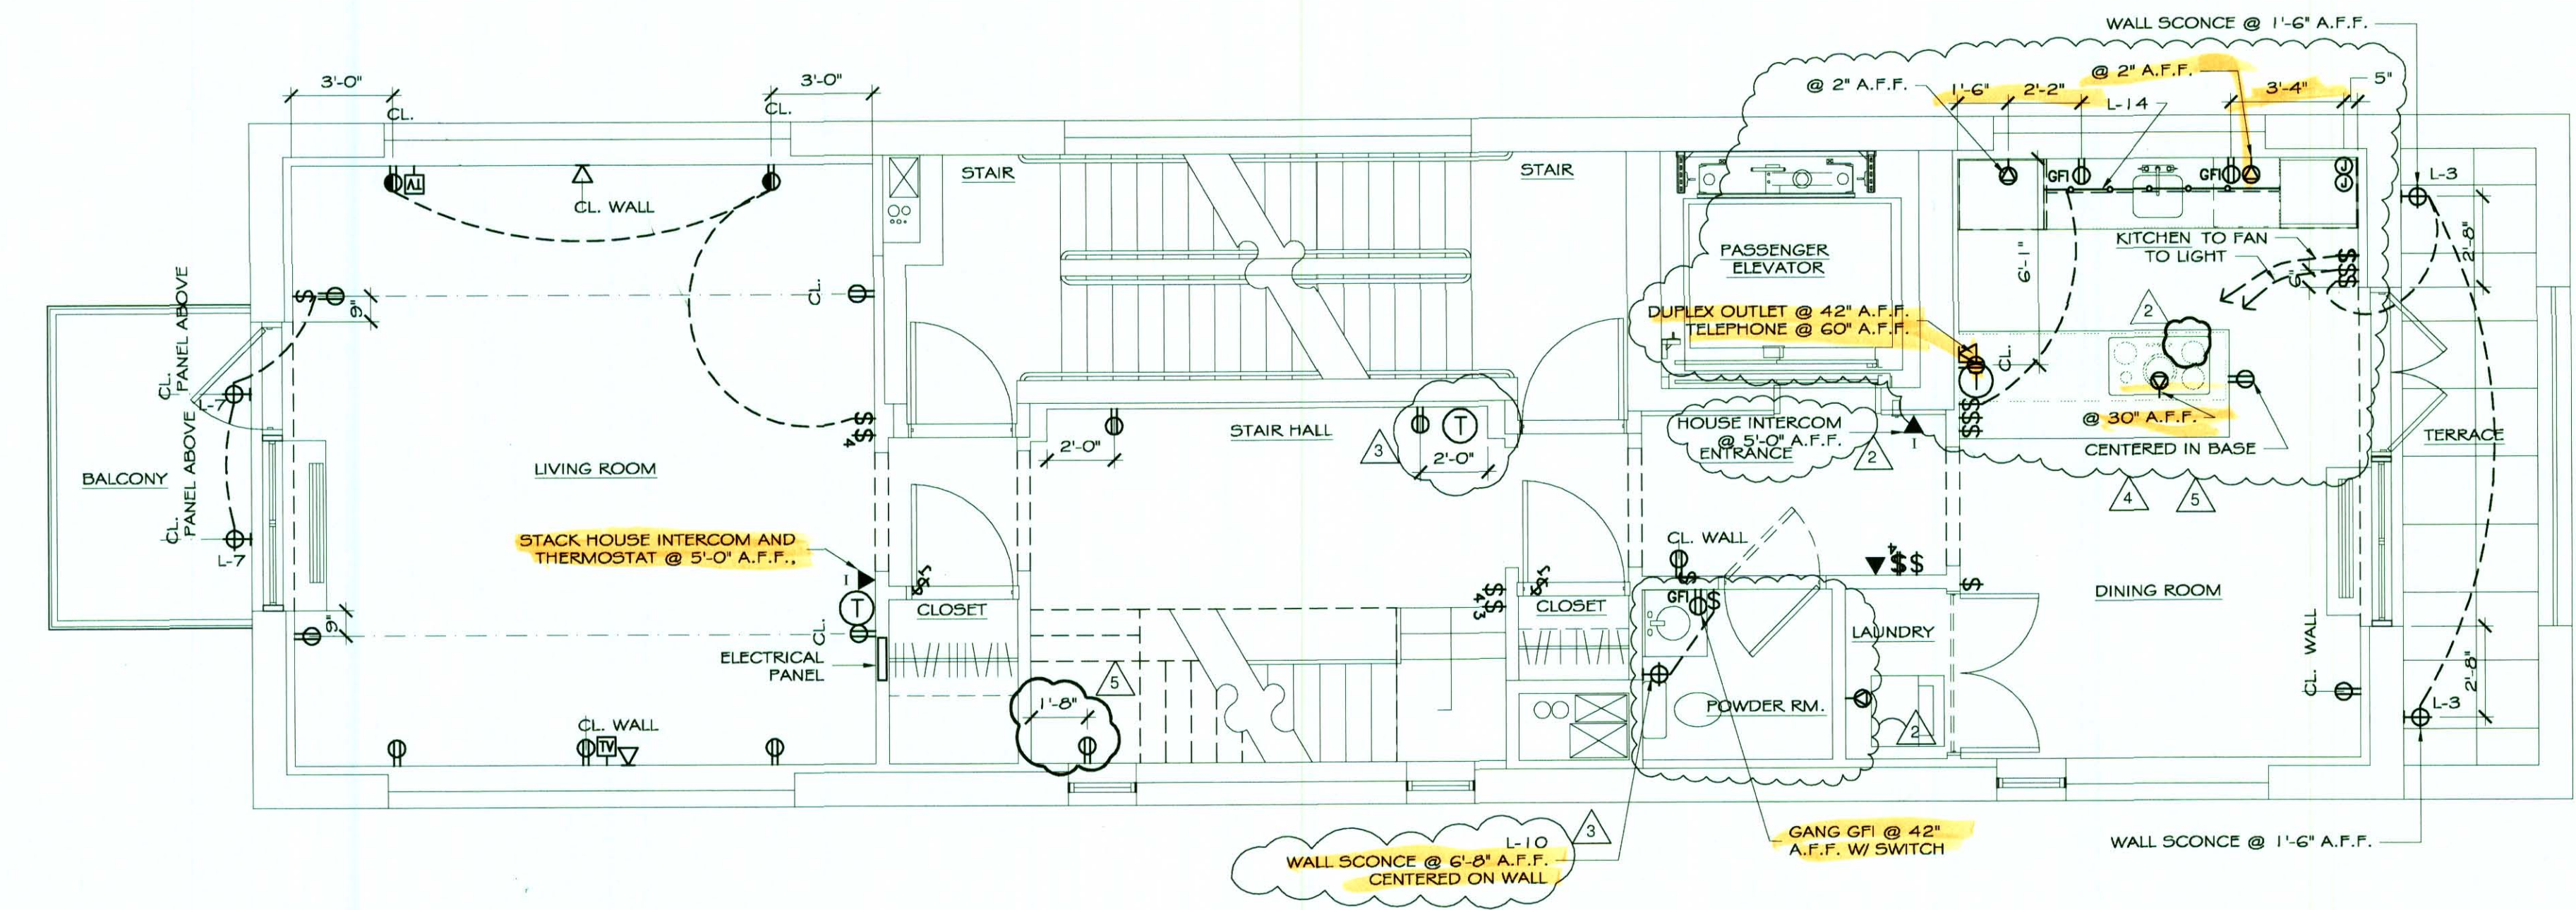

ELECTRICAL PLAN
1/4" = 1'-0"

- LEGEND
- OUTLET W/ DEDICATED CIRCUIT @ 12" A.F.F.
 - SINGLE OUTLET @ 12" A.F.F., U.O.N.
 - DUPLEX OUTLET @ 12" A.F.F., U.O.N.
 - GROUND FAULT INTERRUPTER OUTLET @ 42" A.F.F., U.O.N.
 - DUPLEX OUTLET HALF HOT @ 12" A.F.F., U.O.N.
 - 220 VOLT OUTLET @ 12" A.F.F., U.O.N.
 - QUAD OUTLET @ 12" A.F.F., U.O.N.
 - FLOOR DUPLEX OUTLET
 - FLOOR TELEPHONE JACK
 - WALL SWITCH @ 36" A.F.F.
 - THREE WAY WALL SWITCH @ 36" A.F.F.
 - FOUR WAY WALL SWITCH @ 36" A.F.F.
 - JAMB SWITCH @ 6" A.F.F.
 - KEYED SWITCH
 - SECURITY CARD READER
 - THERMOSTAT @ 5'4" A.F.F.
 - TELEPHONE / DATA JACK @ 12" A.F.F.
 - HOUSE PHONE INTERCOM @ 5'4" A.F.F.
 - SECURITY CAMERA
 - HANDICAP DOOR ACTUATOR
 - CABLE JACK @ 12" A.F.F.
 - STRIP LIGHT
 - WALL SCONCE @ 5'8" A.F.F.
 - JUNCTION BOX
 - SPRINKLER
 - 16" DIA. SURFACE MOUNTED FLUORESCENT LIGHT FIXTURE
 - 16" DIA. SURFACE MOUNTED FLUORESCENT W/ EMERGENCY BATTERY PACK
 - RECESSED LIGHT FIXTURE
 - DIRECTIONAL LIGHT FIXTURE
 - SMOKE DETECTOR
 - CARBON MONOXIDE DETECTOR
 - EXIT LIGHT
 - EMERGENCY BATTERY POWERED LIGHT
 - RETURN AIR GRILLE OR EXHAUST
 - AIR DIFFUSER
 - 22" DIA. SURFACE MOUNTED FLUORESCENT LIGHT FIXTURE
 - SURFACE MOUNTED FLUORESCENT LIGHT FIXTURE @ 8'0" A.F.F. UNLESS OTHER WISE NOTED
 - ACCESS DOOR
 - RETURN AIR GRILLE

- 5 REVISION ISSUED FOR CONSTRUCTION 10/31/08
4 REVISION ISSUED FOR CONSTRUCTION 09/20/07
3 REVISION ISSUED FOR CONSTRUCTION 02/01/07
ISSUED FOR CONSTRUCTION 12/01/06
2 ISSUED FOR CONSTRUCTION 11/17/06
ISSUED FOR PRICING 07/26/06

No.	Revision/Issue	Date
-----	----------------	------

The Deuce
534 W.42nd Street
New York NY 10036

ELECTRICAL &
LIGHTING PLAN
EIGHTH FLOOR

Scale	1/4" = 1'-0"	Sheet No.	E-206
Date	07.26.06		
Drawn By	CCC		