


© Copyright 2005 Brian E. Boyle, AIA
All Rights Reserved
Plans, Drawings, Specifications, Designs, Reports
shown herein, both in paper and electronic
formats are the property of Brian E. Boyle, AIA.
They shall not be used, copied, reprinted,
reproduced, altered or disclosed by any person,
firm, corporation or other entity without the prior
written permission of Brian E. Boyle, AIA.

Brian E. Boyle A.I.A.


75 Spring Street 6th Fl.
New York, NY 10032
212.334.7400
Fax 212.334.6112

General Notes

NOTE

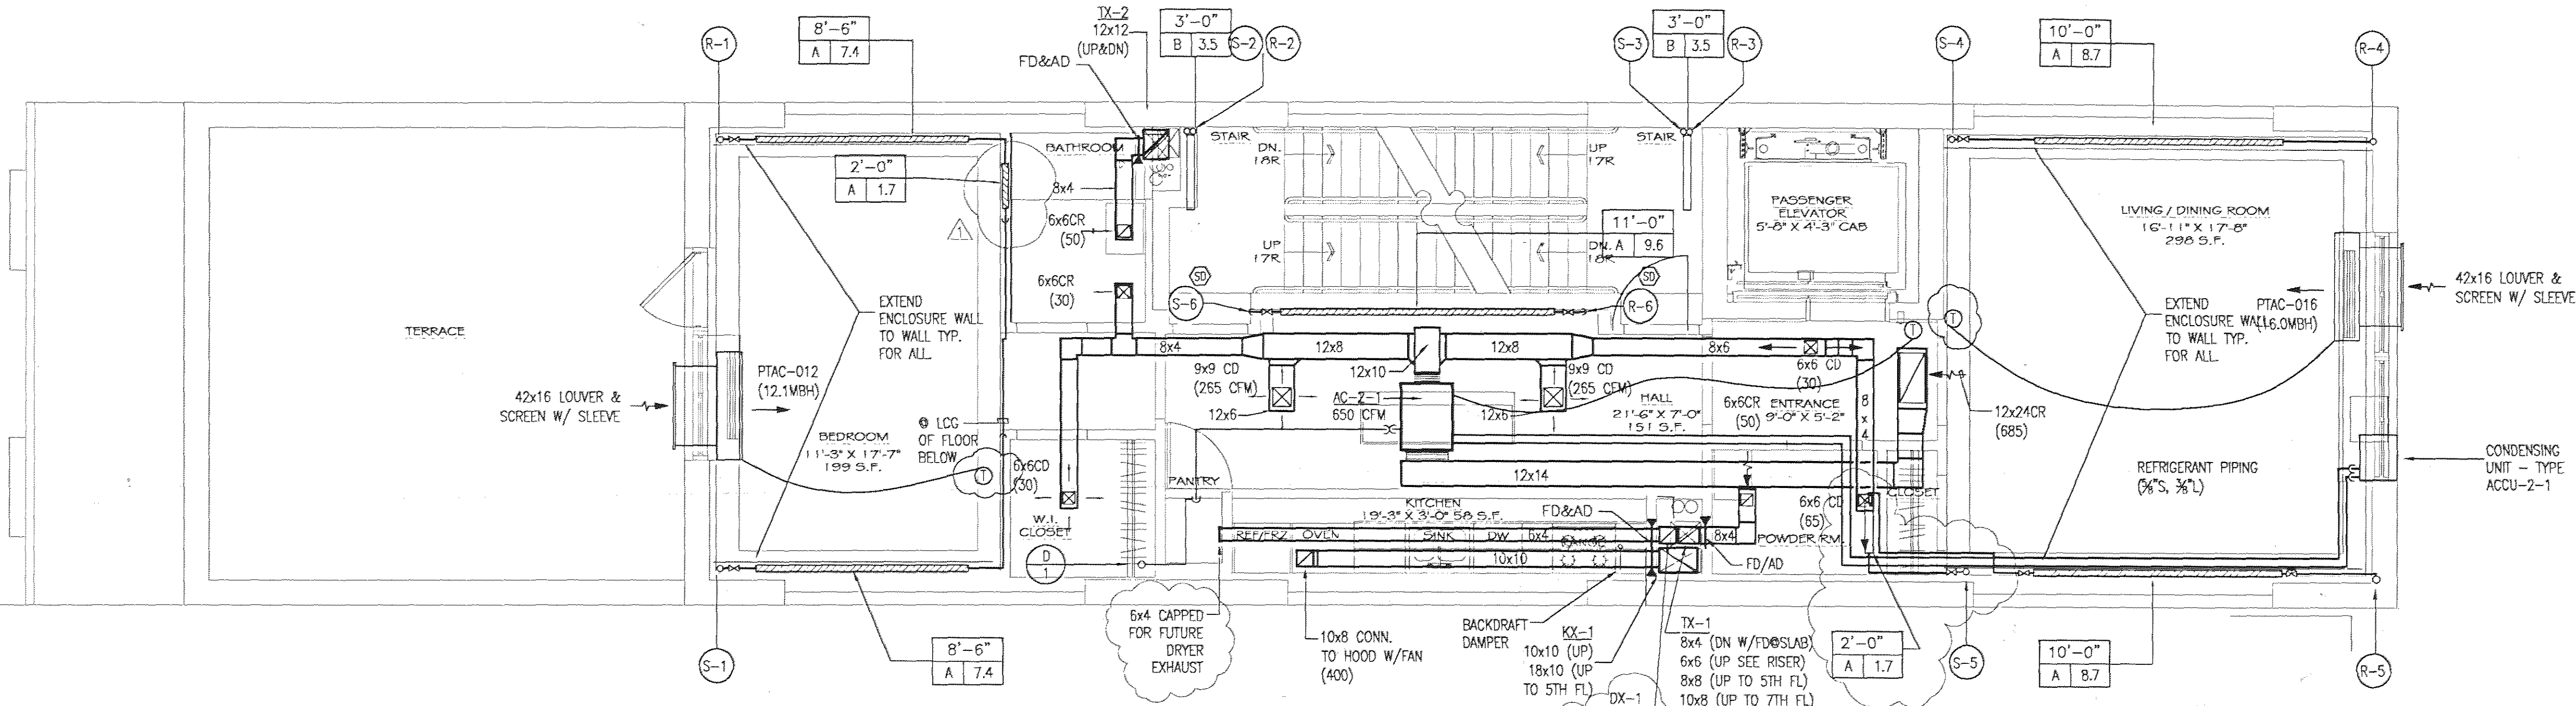

SECOND THRU SEVENTH FLOOR (TYPICAL)

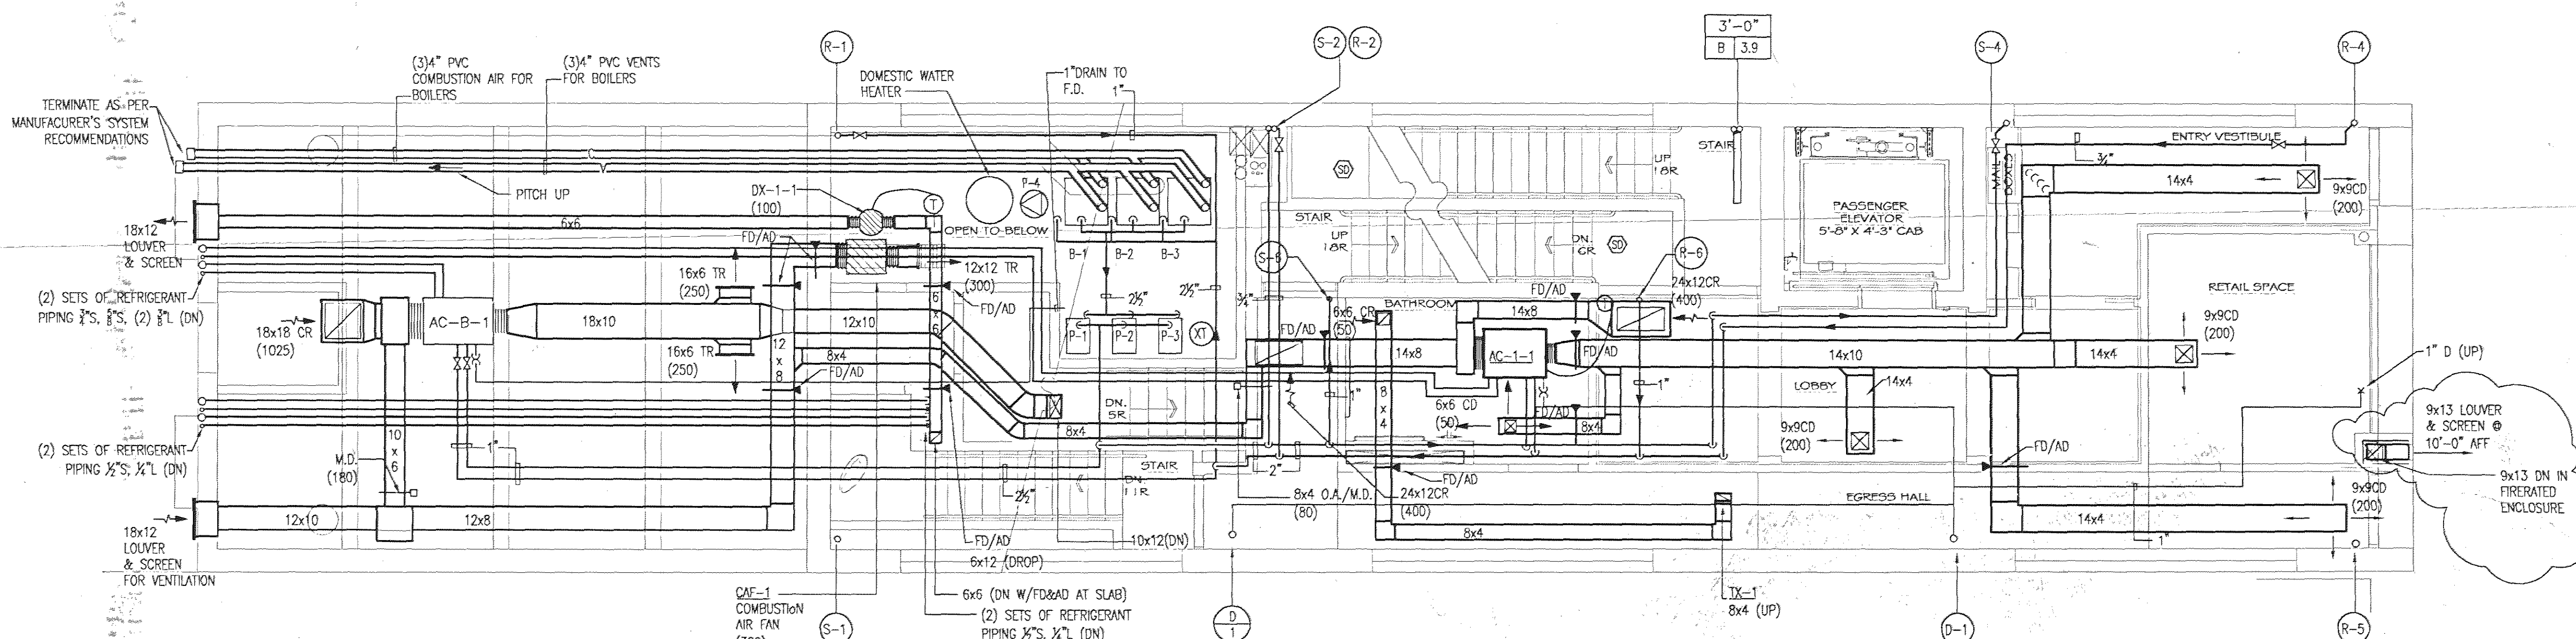

FIRST FLOOR

NOTE
THIS PLAN IS APPROVED ONLY FOR WORK INDICATED ON THE
APPLICATION SPECIFICATION SHEET. ALL OTHER MATTERS SHOWN
ARE NOT TO BE RELIED UPON, OR TO BE CONSIDERED AS BEING
EITHER APPROVED OR IN ACCORDANCE WITH APPLICABLE CODES.

MAR
M. A. RUBIANO, P.C.
CONSULTING ENGINEERS
45 JOHN STREET, SUITE 903
N.Y., N.Y. 10038 (212) 732-7842

2	F.A.I. GRILLE	06.25.07
1	GENERAL REVISION	10.16.06
	CONSTRUCTION SET	10.18.06
	BID SET	10.18.06
	ISSUED	03.20.06

No.	Revision/Issue	Date
-----	----------------	------

The Deuce
534 West 42nd Street
New York, NY 10036

HVAC PLAN
FIRST, SECOND THRU
FOURTH FLOOR PLANS

Scale	1/4" = 1'-0"	Sheet No.
Date	10-10-2006	M-103
Drawn by	REM	