


Copyright 2005 Brian E. Boyle AIA
All Rights Reserved
Plans, Drawings, Specifications, Designs, Notes
shown herein, in all or in part, and electronic
formats, are the property of Brian E. Boyle AIA.
They shall not be used, copied and/or
reproduced, altered or disclosed to any person
firm, corporation or other entity without the prior
written permission of Brian E. Boyle AIA.

Brian E. Boyle A.I.A.

75 Spring Street 6th Flr
New York, NY 10002
212.334.7402
Fax 212.334.6112

General Notes

NOTE

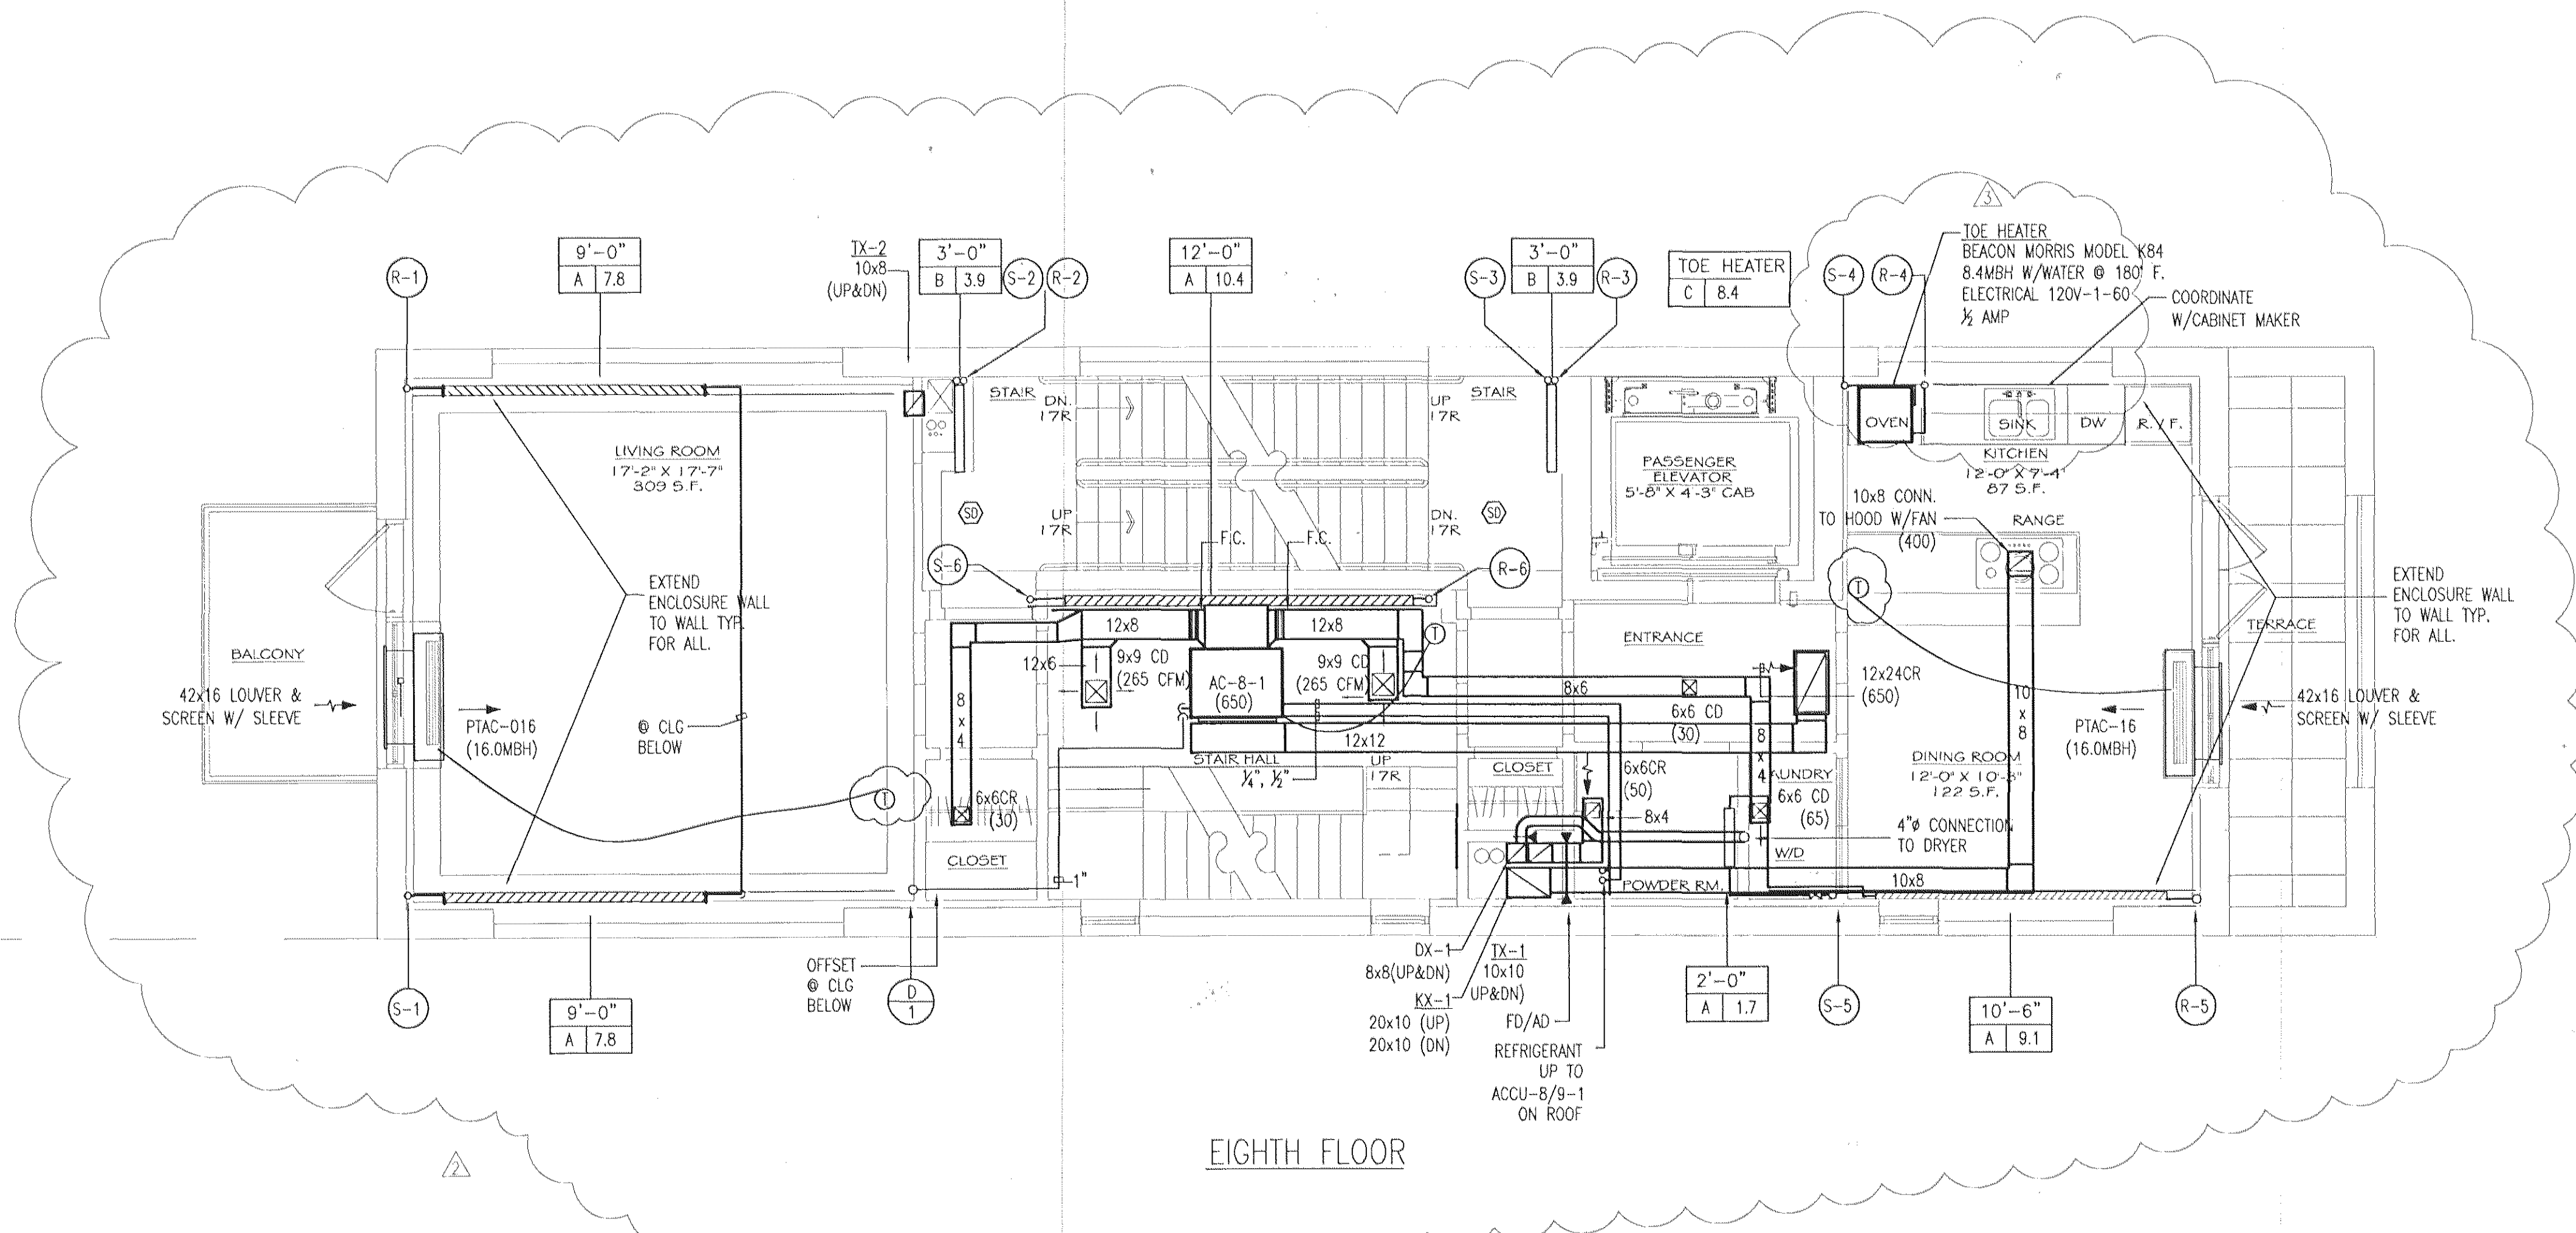

EIGHTH FLOOR

△	PTAC	03.18.08
△	ELIMINATE CITY MULTI	02.25.08
△	GENERAL REVISION	11.05.07
△	GENERAL REVISION	10.18.06

4	ISSUED FOR PERMIT	01.22.08
3	CONSTRUCTION SET	10.18.06
2	BID SET	10.18.06
1	ISSUED	03.20.06

No.	Revision/Issue	Date
The Deuce 534 West 42nd Street New York, NY 10036		
HVAC PLAN EIGHTH FLOOR PLAN		
Scale	1/4" = 1'-0"	Sheet No.
Date	10-10-2006	M-104
Drawn By	REM	

NOTE
THIS PLAN IS APPROVED ONLY FOR WORK INDICATED ON THE
APPLICATION SPECIFICATION SHEET. ALL OTHER MATTERS SHOWN
ARE NOT TO BE RELIED UPON, OR TO BE CONSIDERED AS BEING
EITHER APPROVED OR IN ACCORDANCE WITH APPLICABLE CODES.

MAR
M. A. RUBIANO, P.C.
CONSULTING ENGINEERS
64 FULTON STREET, SUITE 505
N.Y., N.Y. 10038 (212) 732-7842