

Copyright 2005 Brian E. Boyle, AIA
All Rights Reserved
Plans, Drawings, Specifications, Designs, Ideas
Shown Herein, Both in Paper and Electronic
Format are the property of Brian E. Boyle, AIA.
They shall not be used, copied and/or
reproduced, altered or disclosed by any person,
firm, corporation or other entity without the prior
written permission of Brian E. Boyle, AIA.


Brian E. Boyle A.I.A.

75 Spring Street 6th Flr
New York, NY 10002
212.334.7402
Fax 212.334.6112


General Notes

NOTE


1 SECOND FLOOR PLAN

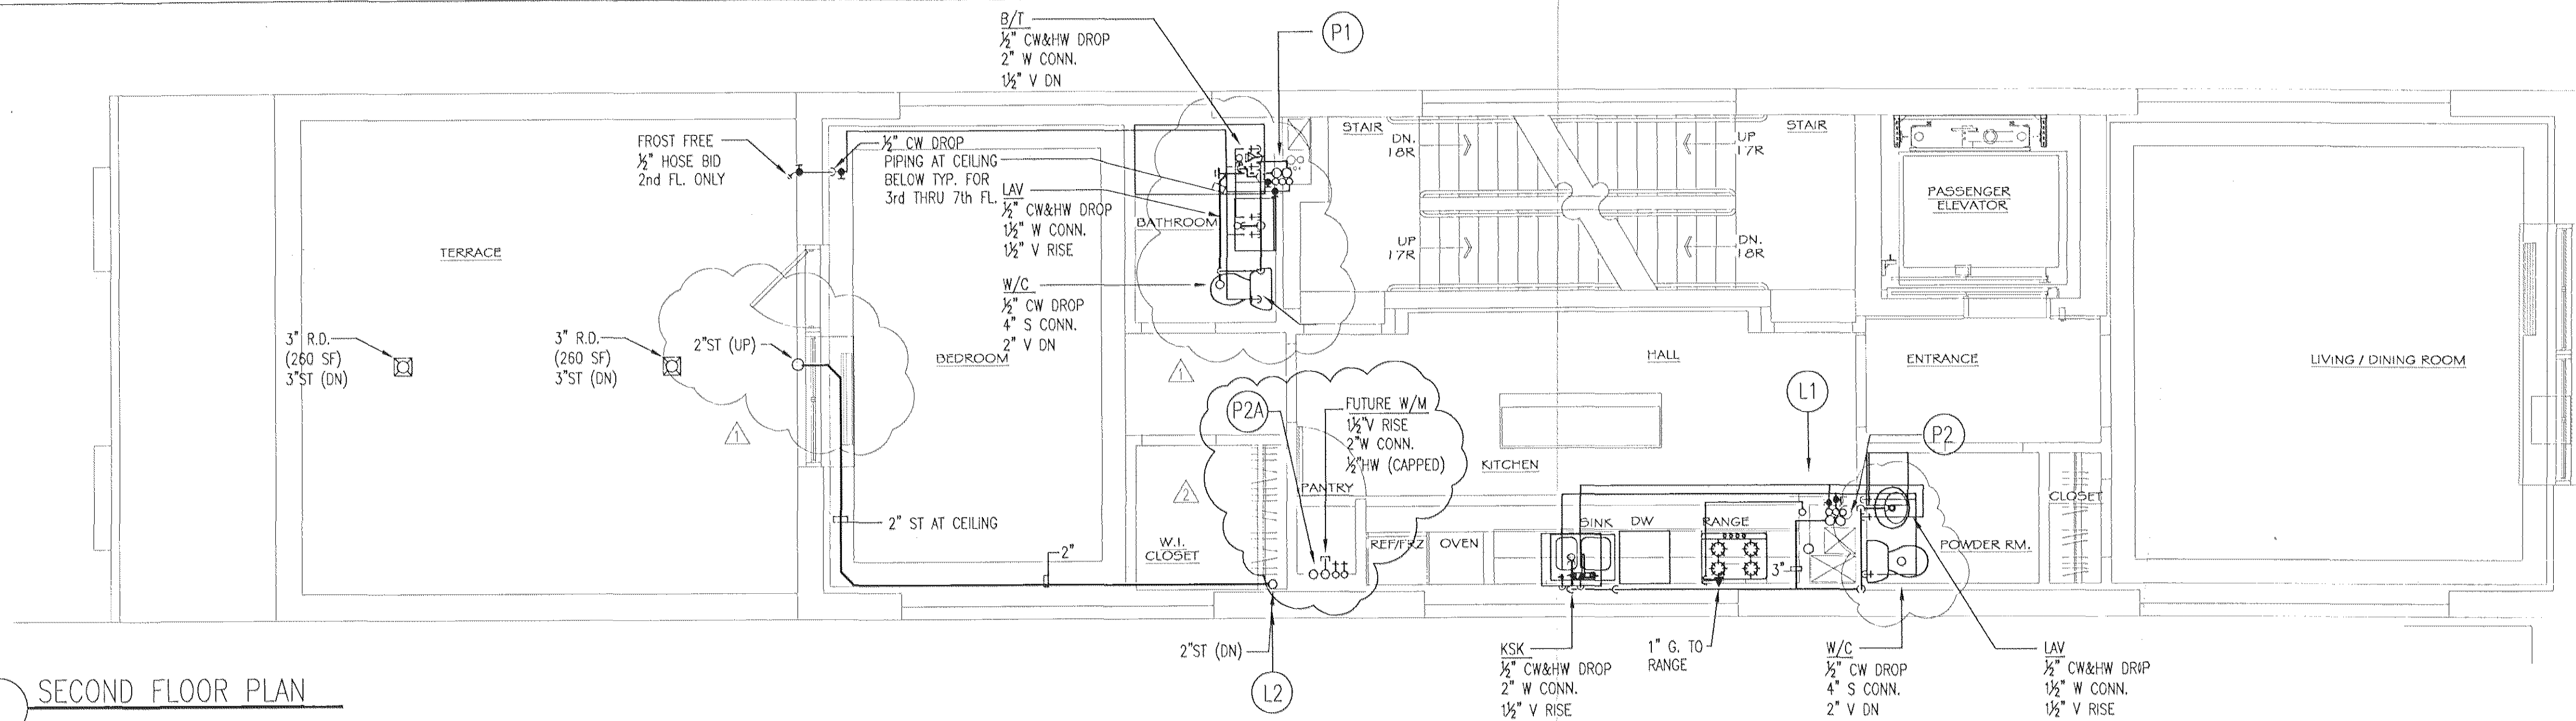

1 FIRST FLOOR PLAN

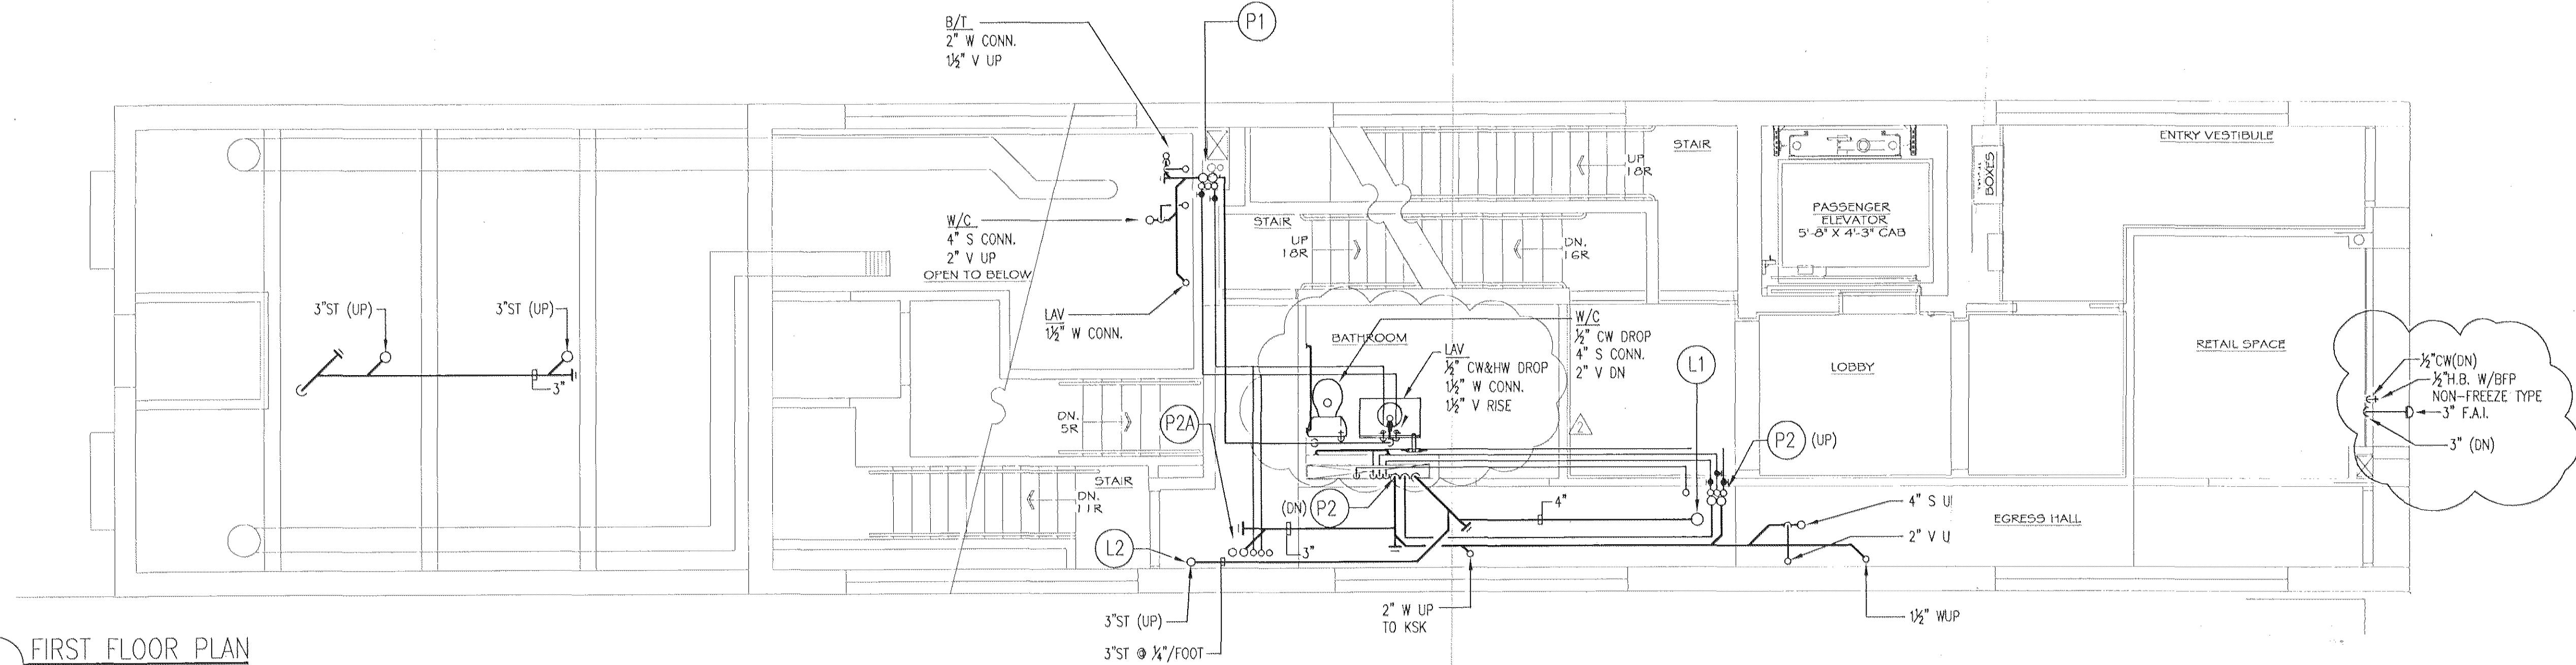

1 CELLAR PLAN

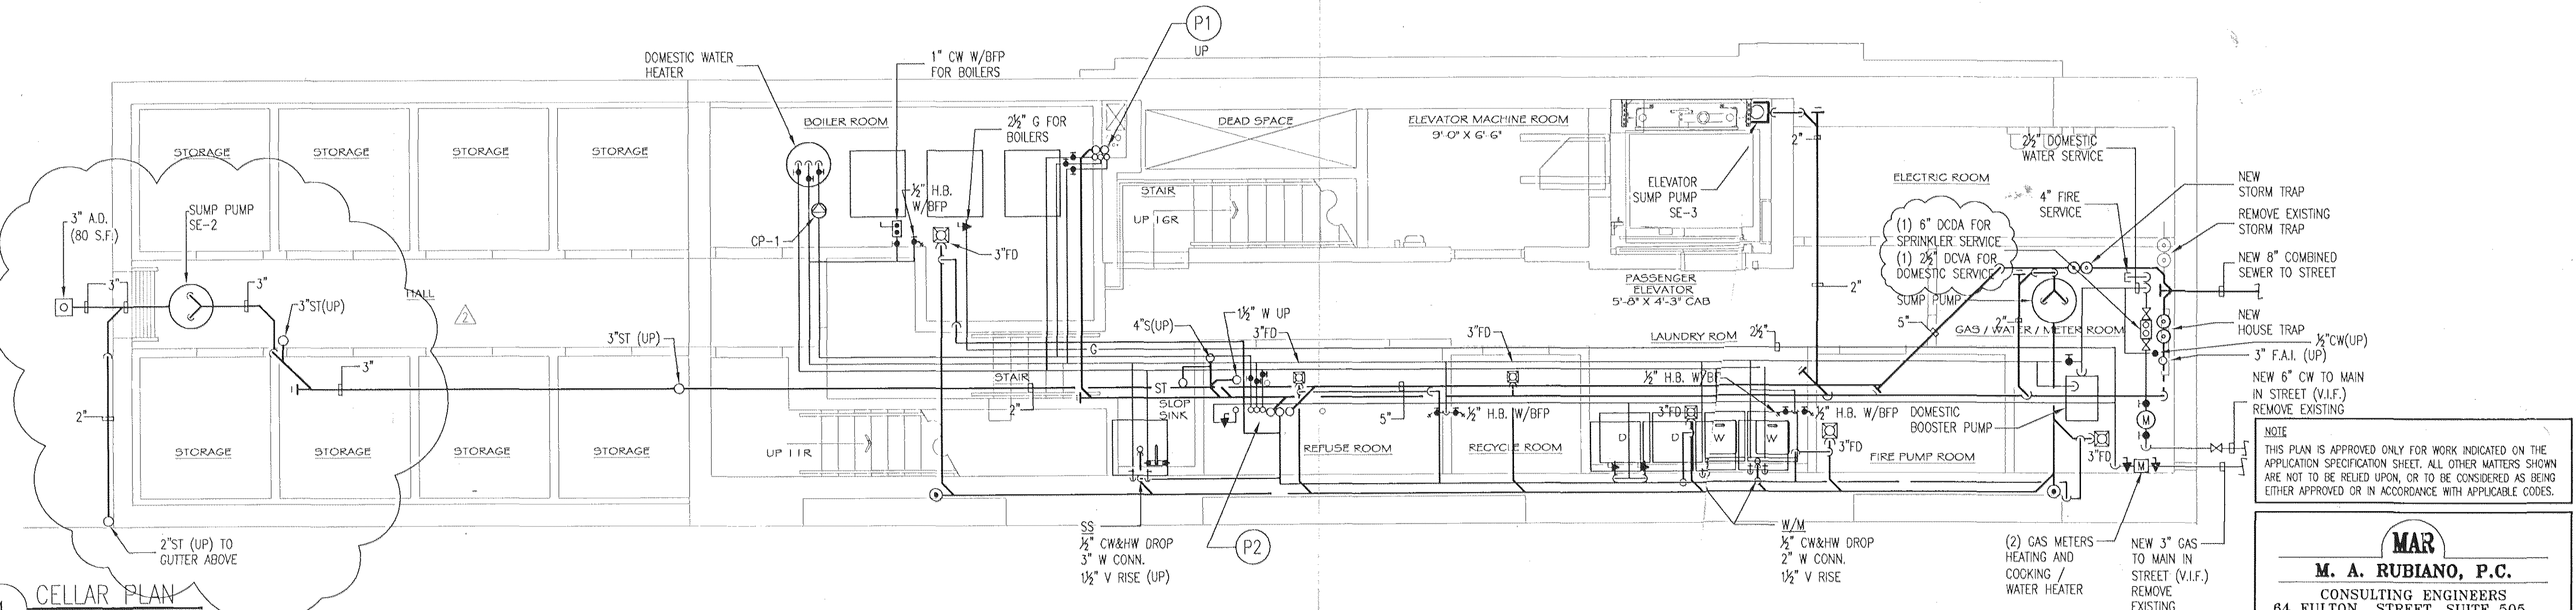

△	GENERAL REVISION	12.04.07
△	GENERAL REVISION	10.18.06

4	ISSUED FOR PERMIT	01.22.08
3	CONSTRUCTION SET	10.18.06
2	BID SET	06.01.06
1	ISSUED/REVISION	00.00.00

No.	Revision/Issue	Date
-----	----------------	------

The Deuce
534 West 42nd Street
New York NY 10036

PLUMBING PLAN
BASEMENT, FIRST &
SECOND FLOOR

MAR
M. A. RUBIANO, P.C.
CONSULTING ENGINEERS
64 FULTON STREET, SUITE 505
N.Y., N.Y. 10038 (212) 732-7842

Scale	1/4" = 1'-0"	Sheet No.
Date	10-10-2006	P-102
Drawn By	...	