





Copyright 2005 Brian E. Boyle, AIA
All Rights Reserved
Plans, Drawings, Specifications, Designs, Ideas
shown herein, both in paper and electronic
formats are the property of Brian E. Boyle, AIA.
They shall not be used, copied and/or
reproduced, altered or disclosed by any person,
firm, corporation or other entity without the prior
written permission of Brian E. Boyle, AIA.

Brian E. Boyle A.I.A.

75 Spring Street 8th Fl
New York, NY 10002
212.334.7402
Fax 212.334.6112

General Notes

NOTE

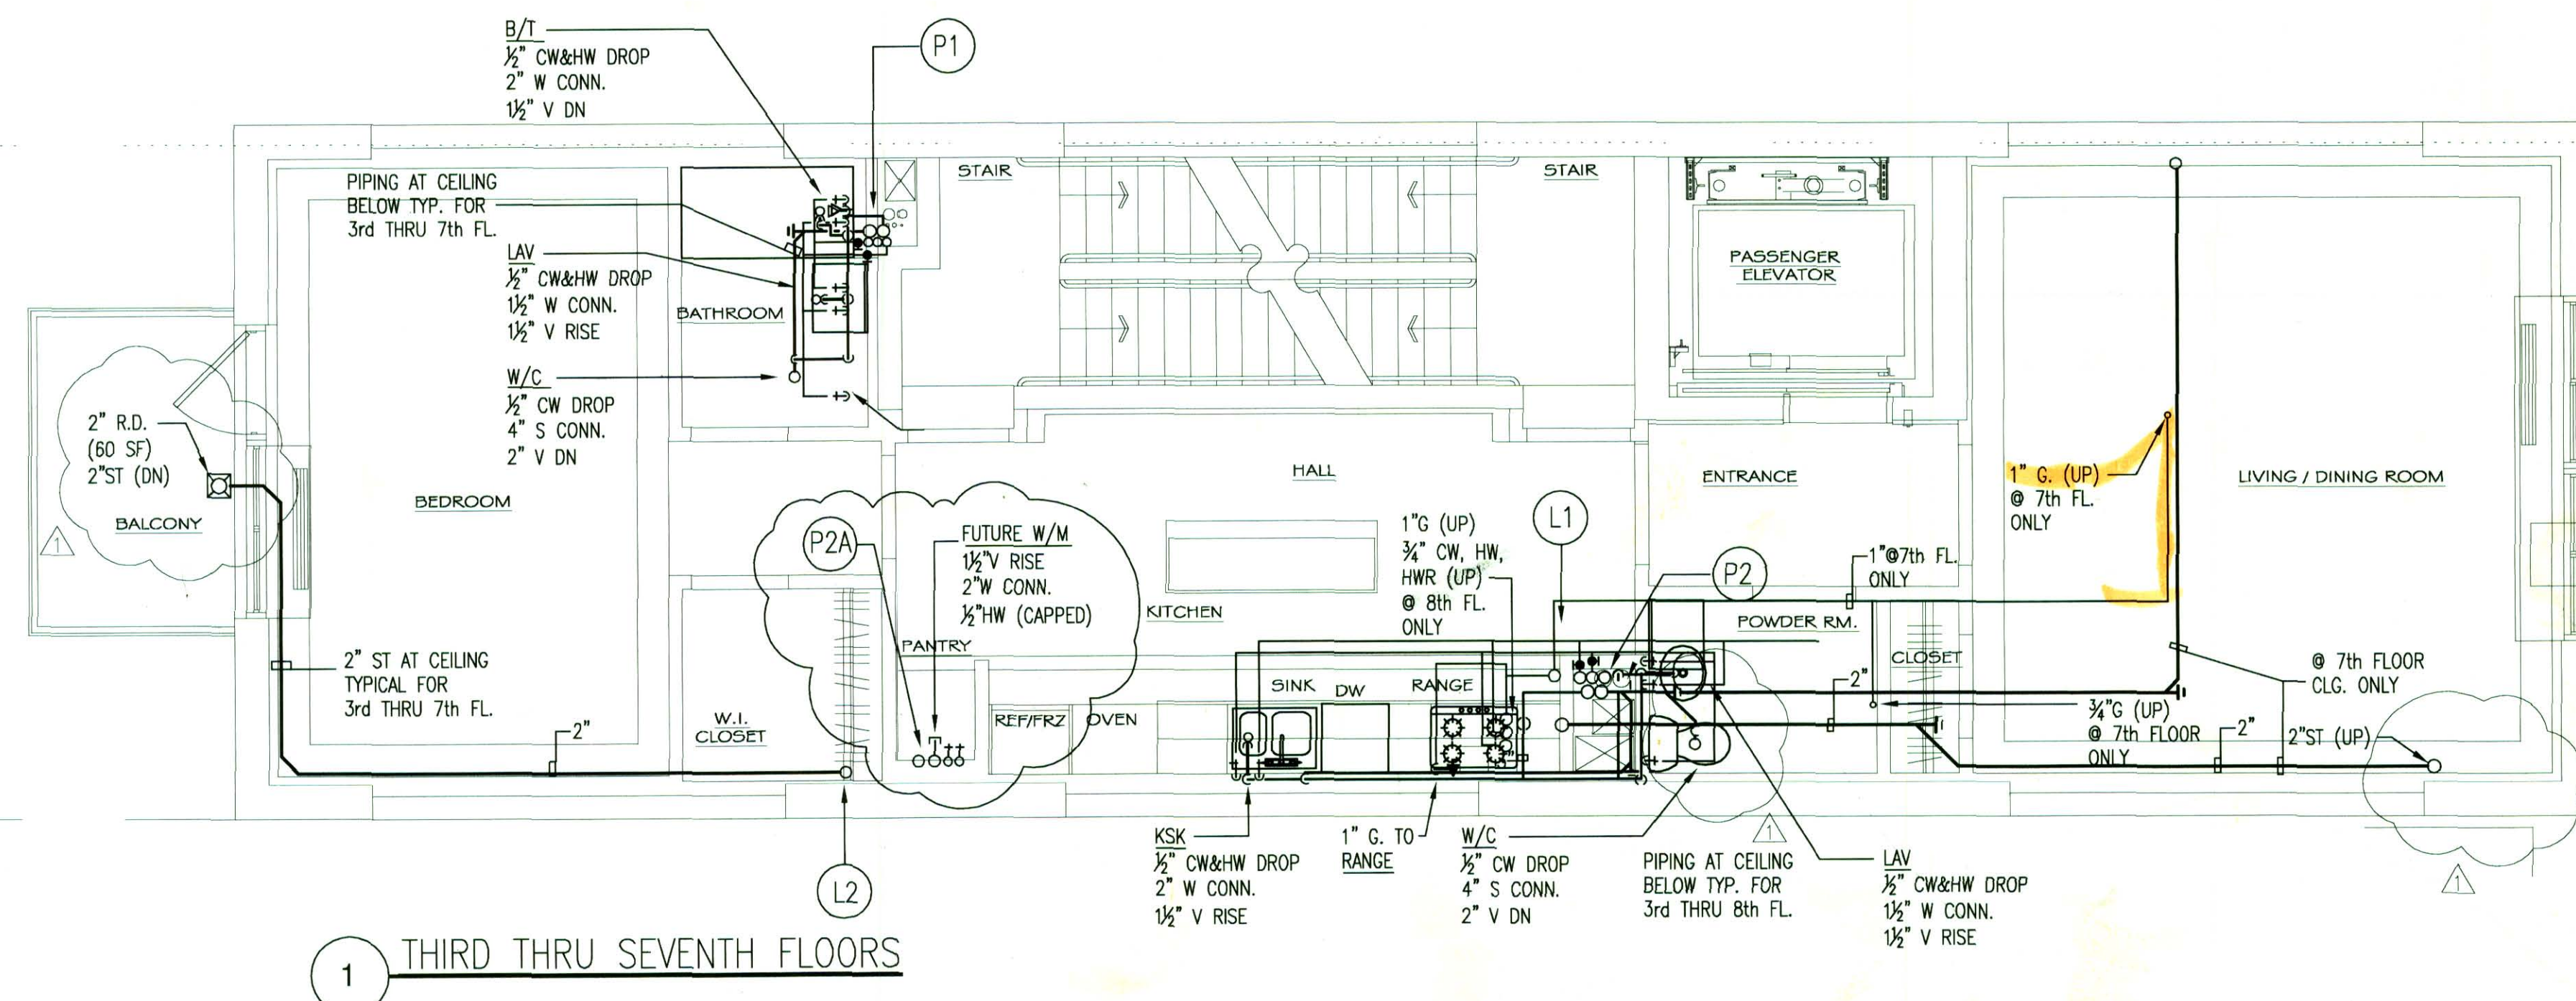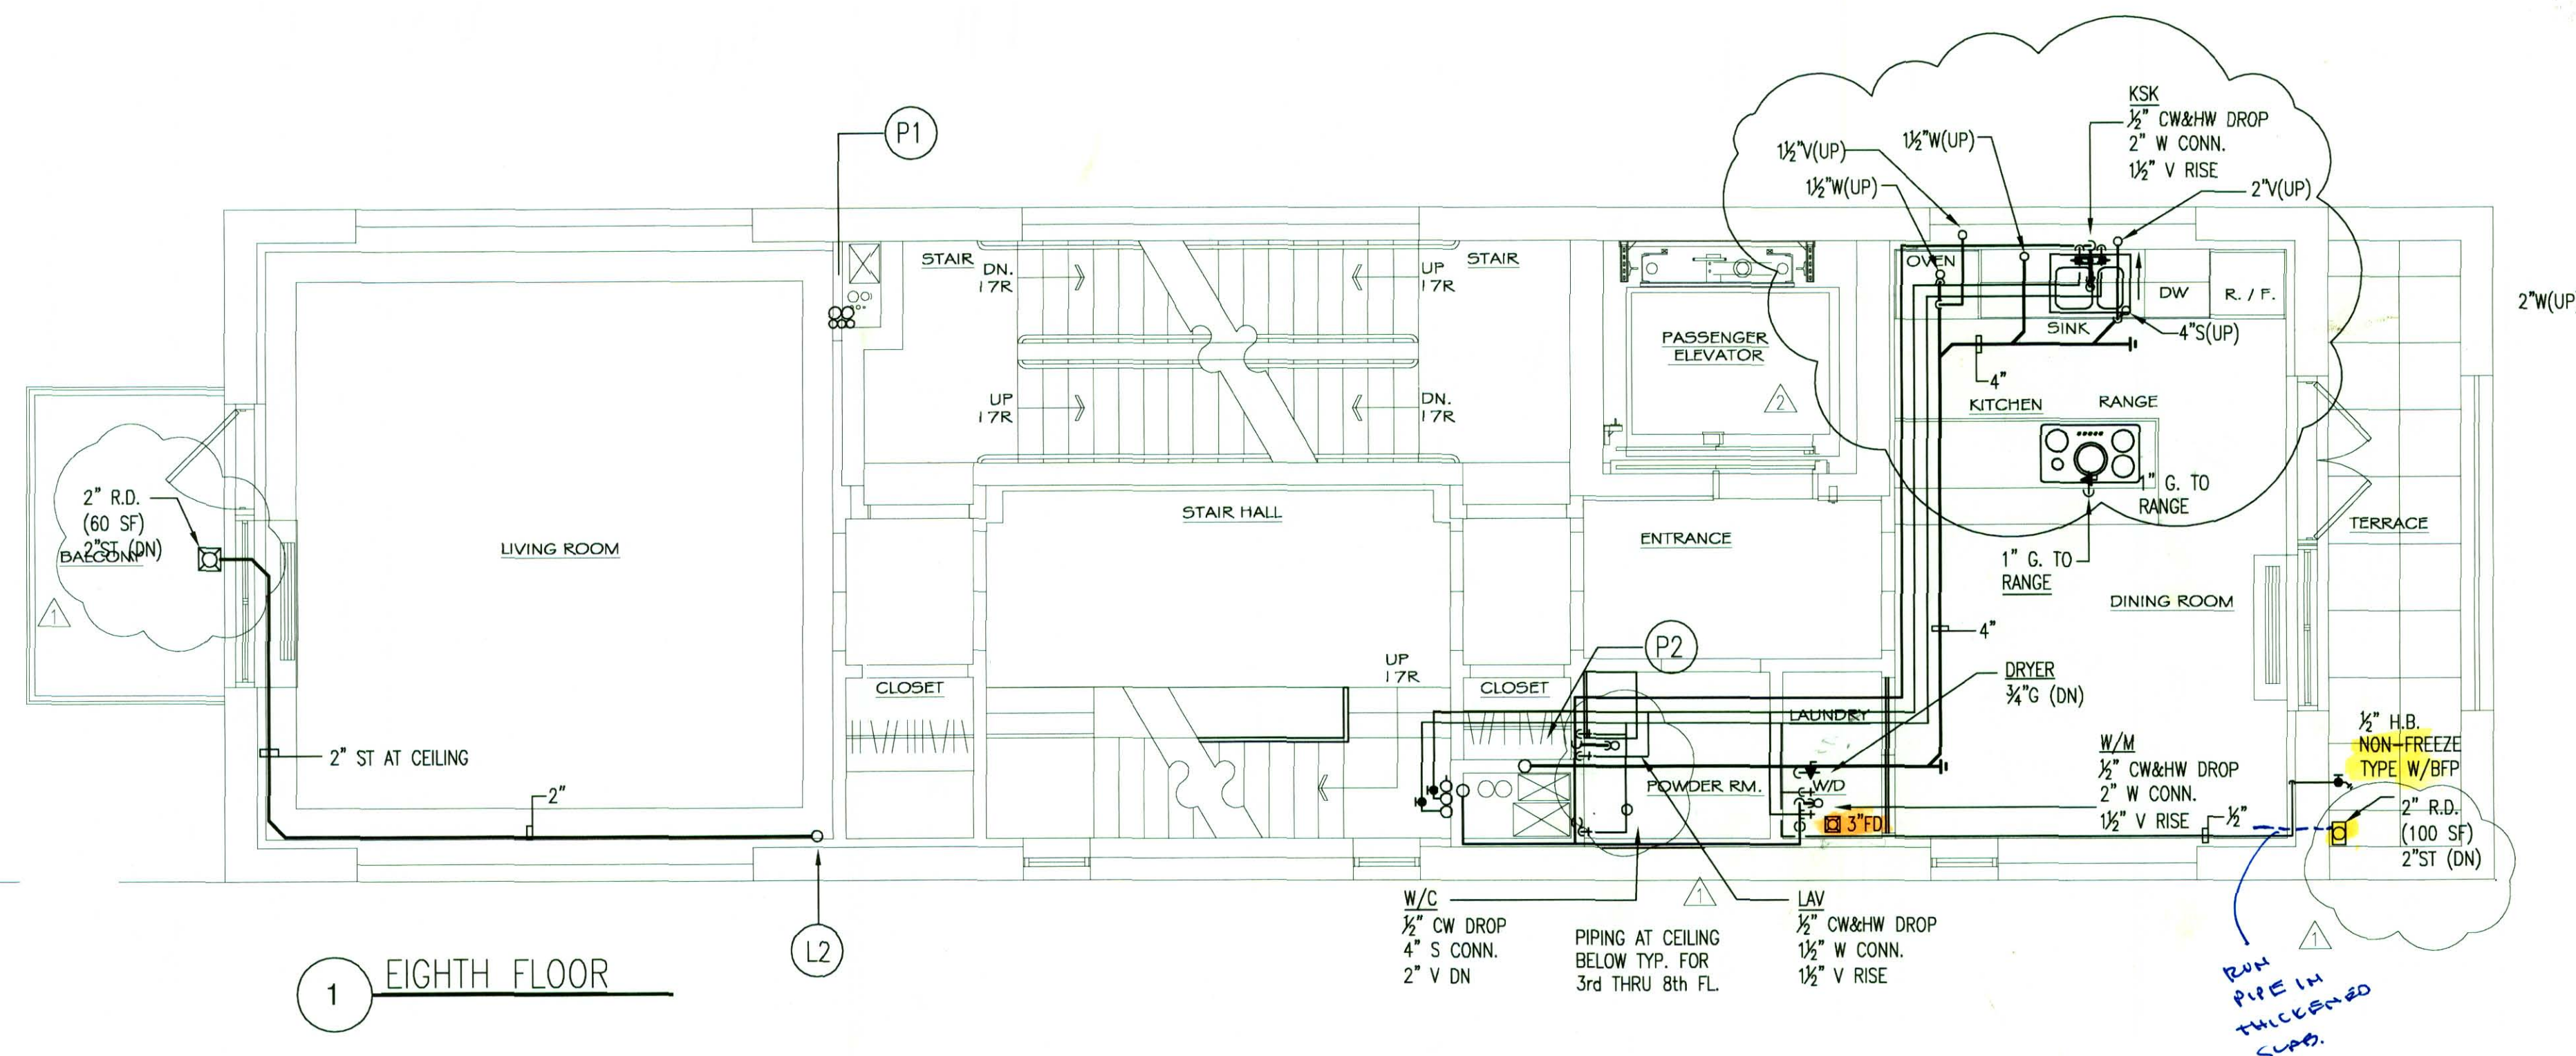

GENERAL REVISION	12.04.07
GENERAL REVISION	10.18.06

4	ISSUED FOR PERMIT	01.22.08
3	CONSTRUCTION SET	10.18.06
2	BID SET	06.01.06
1	ISSUED	03.20.06

No.	Revision/Issue	Date
-----	----------------	------

The Deuce
534 West 42nd Street
New York NY 10036

PLUMBING PLAN
THIRD THRU SEVENTH &
EIGHT FLOOR

NOTE
THIS PLAN IS APPROVED ONLY FOR WORK INDICATED ON THE
APPLICATION SPECIFICATION SHEET. ALL OTHER MATTERS SHOWN
ARE NOT TO BE RELIED UPON, OR TO BE CONSIDERED AS BEING
EITHER APPROVED OR IN ACCORDANCE WITH APPLICABLE CODES.

MAR
M. A. RUBIANO, P.C.
CONSULTING ENGINEERS
64 FULTON STREET, SUITE 505
N.Y., N.Y. 10038 (212) 732-7842

Scale	1/4" = 1'-0"	Sheet No.
Date	10-10-2006	P-103
Drawn By	---	