

Copyright 2005 Brian E. Boyle, AIA
All rights reserved. No part of this publication may be reproduced, stored in a retrieval system, or transmitted, in any form or by any means, electronic, mechanical, photocopying, recording, or by any information storage and retrieval system, without the prior written permission of Brian E. Boyle, AIA.

75 Spring Street 6th Fl.
New York, NY 10002
212.334.7402
Fax: 212.334.6112

Brian E. Boyle A.I.A.

LEGEND

- AREA OF DROPPED OFF-BL. SOFFIT
- AREA OF DROPPED OFF-BL. CEILING
- FINED OUT RATED CEILING 1 LAYER 1/2" TYPE IV GYP. BX.
- 2 HOUR RATED CEILING OR SOFFIT
- SECURITY CAMERA
- JUNCTION BOX
- SPRINKLER
- 1/2" DIA. SURFACE MOUNTED FLUORESCENT LIGHT FIXTURE
- 1/2" DIA. SURFACE MOUNTED FLUORESCENT LIGHT FIXTURE
- 1/2" DIA. SURFACE MOUNTED FLUORESCENT LIGHT FIXTURE
- RECESSED LIGHT FIXTURE
- DIRECTIONAL LIGHT FIXTURE
- SHADE DETECTOR
- CARBON MONOXIDE DETECTOR
- EXIT LIGHT
- EMERGENCY BATTERY POWERED LIGHT
- RETURN AIR GRILLE ON SHAFT
- AIR DIFFUSER
- 27" DIA. SURFACE MOUNTED FLUORESCENT LIGHT FIXTURE
- PERIMETER FLUORESCENT LIGHT FIXTURE
- ACCESS DOOR
- RETURN AIR AIR GRILLE


△ ISSUED FOR SHOP DRAWINGS
12.05.07
ISSUED FOR CONSTRUCTION
08.01.08
ISSUED FOR REVIEW
05.25.05

No.	Revision/Issue	Date
-----	----------------	------


The Deuce
534 W 42nd Street
New York, NY 10036

REFLECTED CEILING PLAN
CELLAR AND
FIRST FLOOR

Scale 1/4" = 1'-0"	Sheet No. A-120
Date 08-01-2006	
Drawn By CCC	

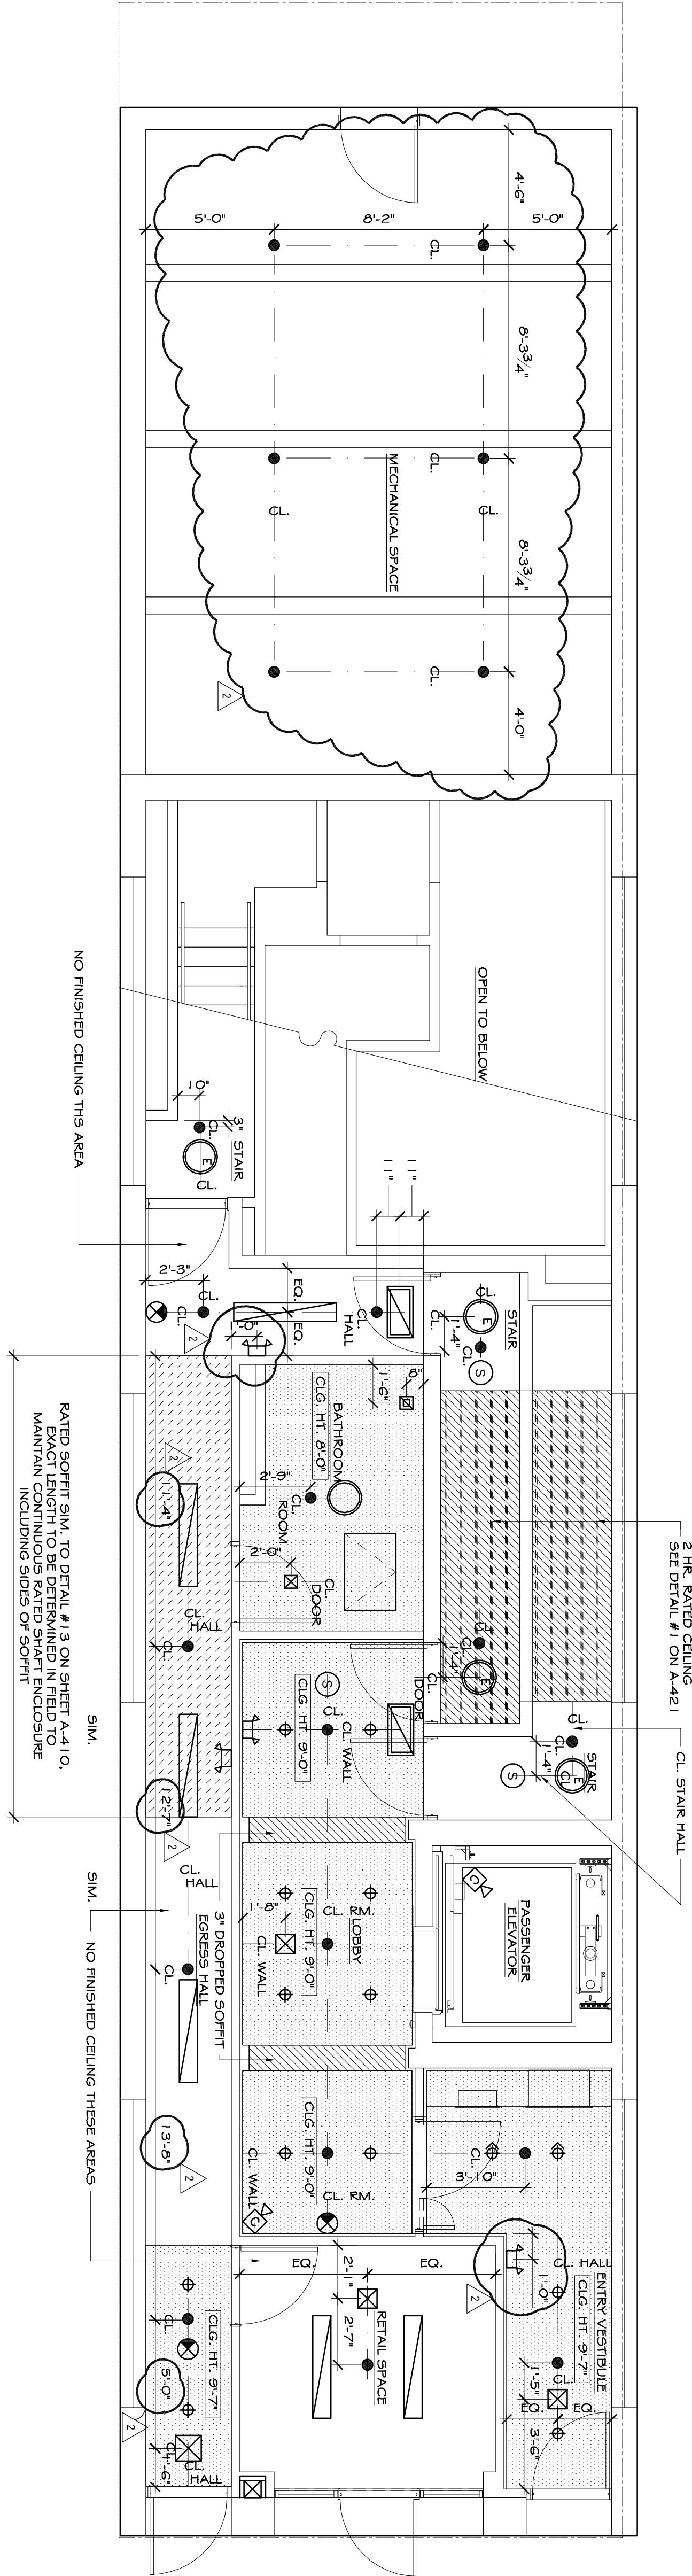

FIRST FLOOR PLAN
1/4" = 1'-0"

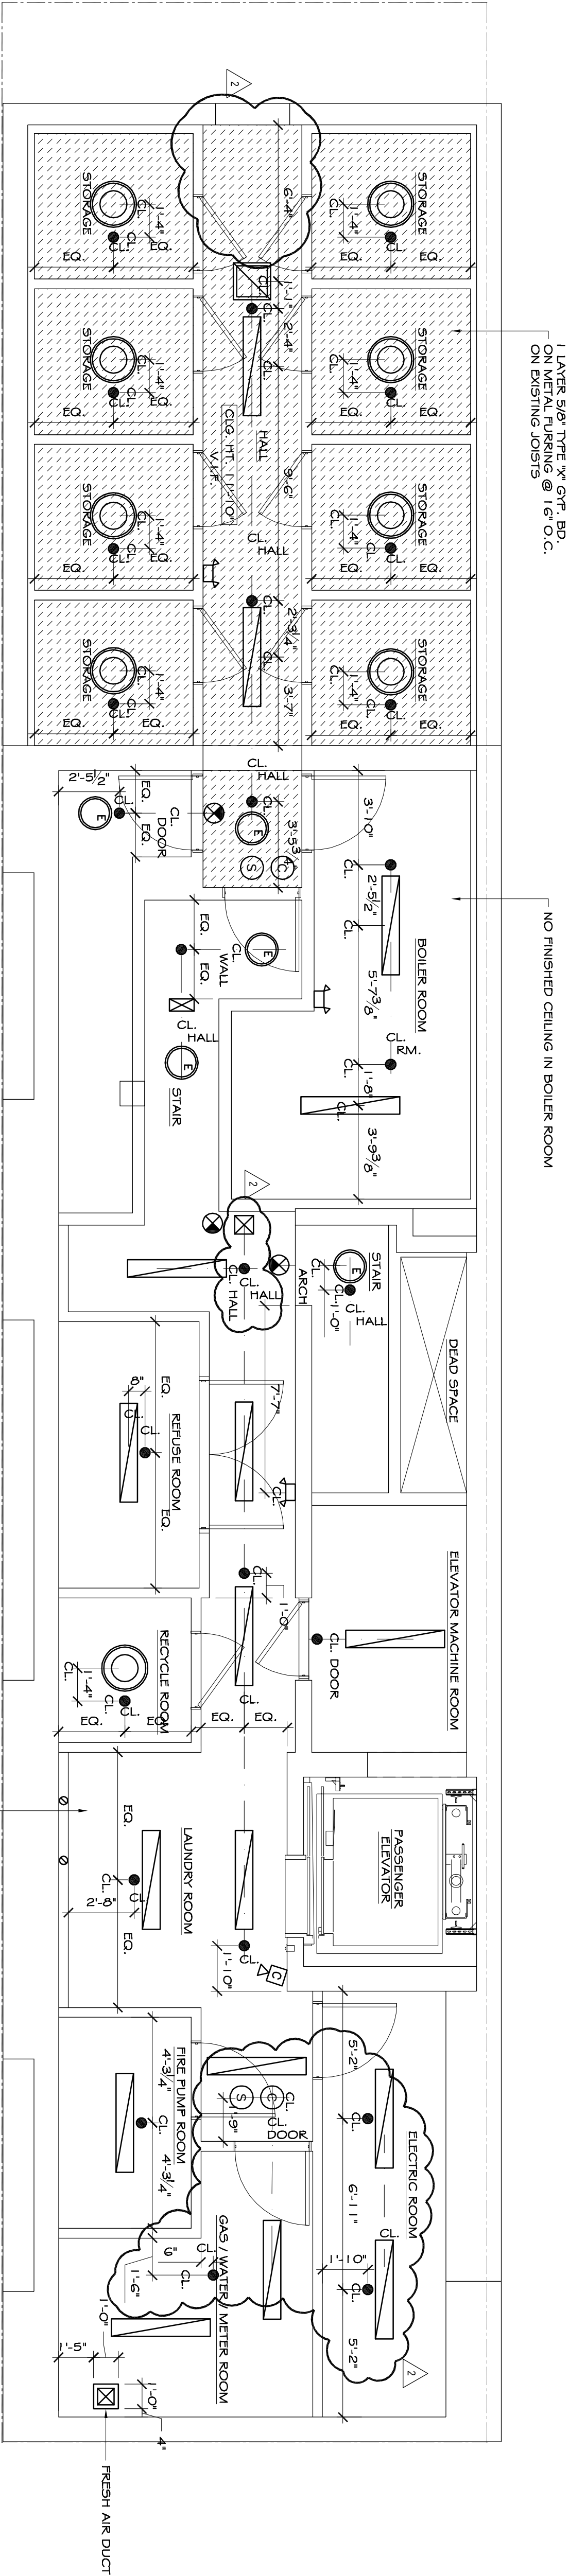

CELLAR
1/4" = 1'-0"