




Copyright 2006 Brian E. Boyle AIA
All Rights Reserved
Plans, Drawings, Specifications, Designs, Ideas
shown herein, both in paper and electronic
formats are the property of Brian E. Boyle AIA.
They shall not be used, copied and/or
reproduced, shared or disclosed by any person
firm, corporation or other entity without the prior
written permission of Brian E. Boyle AIA.


Brian E. Boyle A.I.A.

75 Spring Street 8th Flr
New York, NY 10002
212.334.7402
Fax 212.334.6112

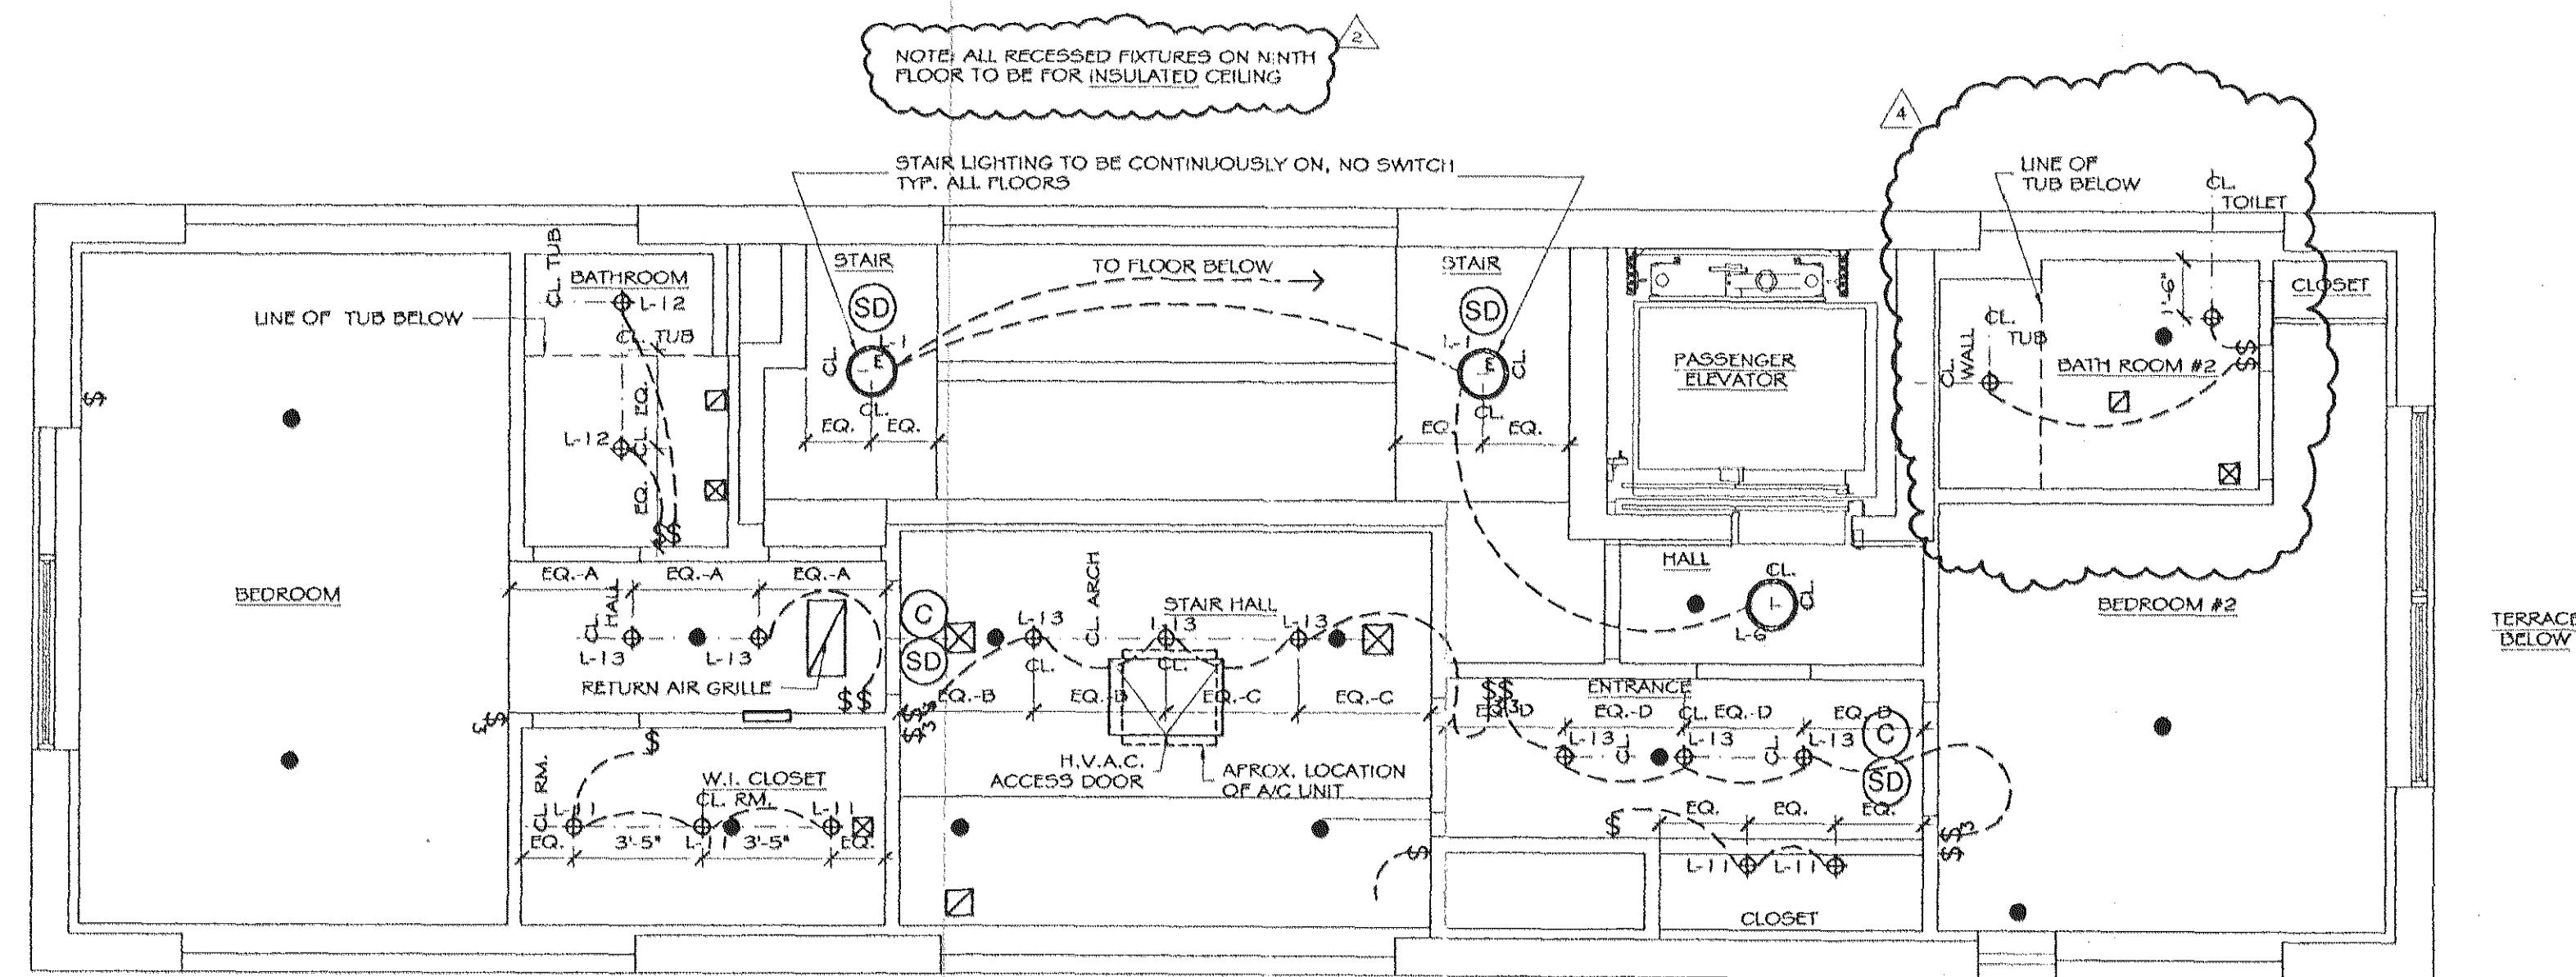

LIGHTING PLAN

1/4" = 1'-0"

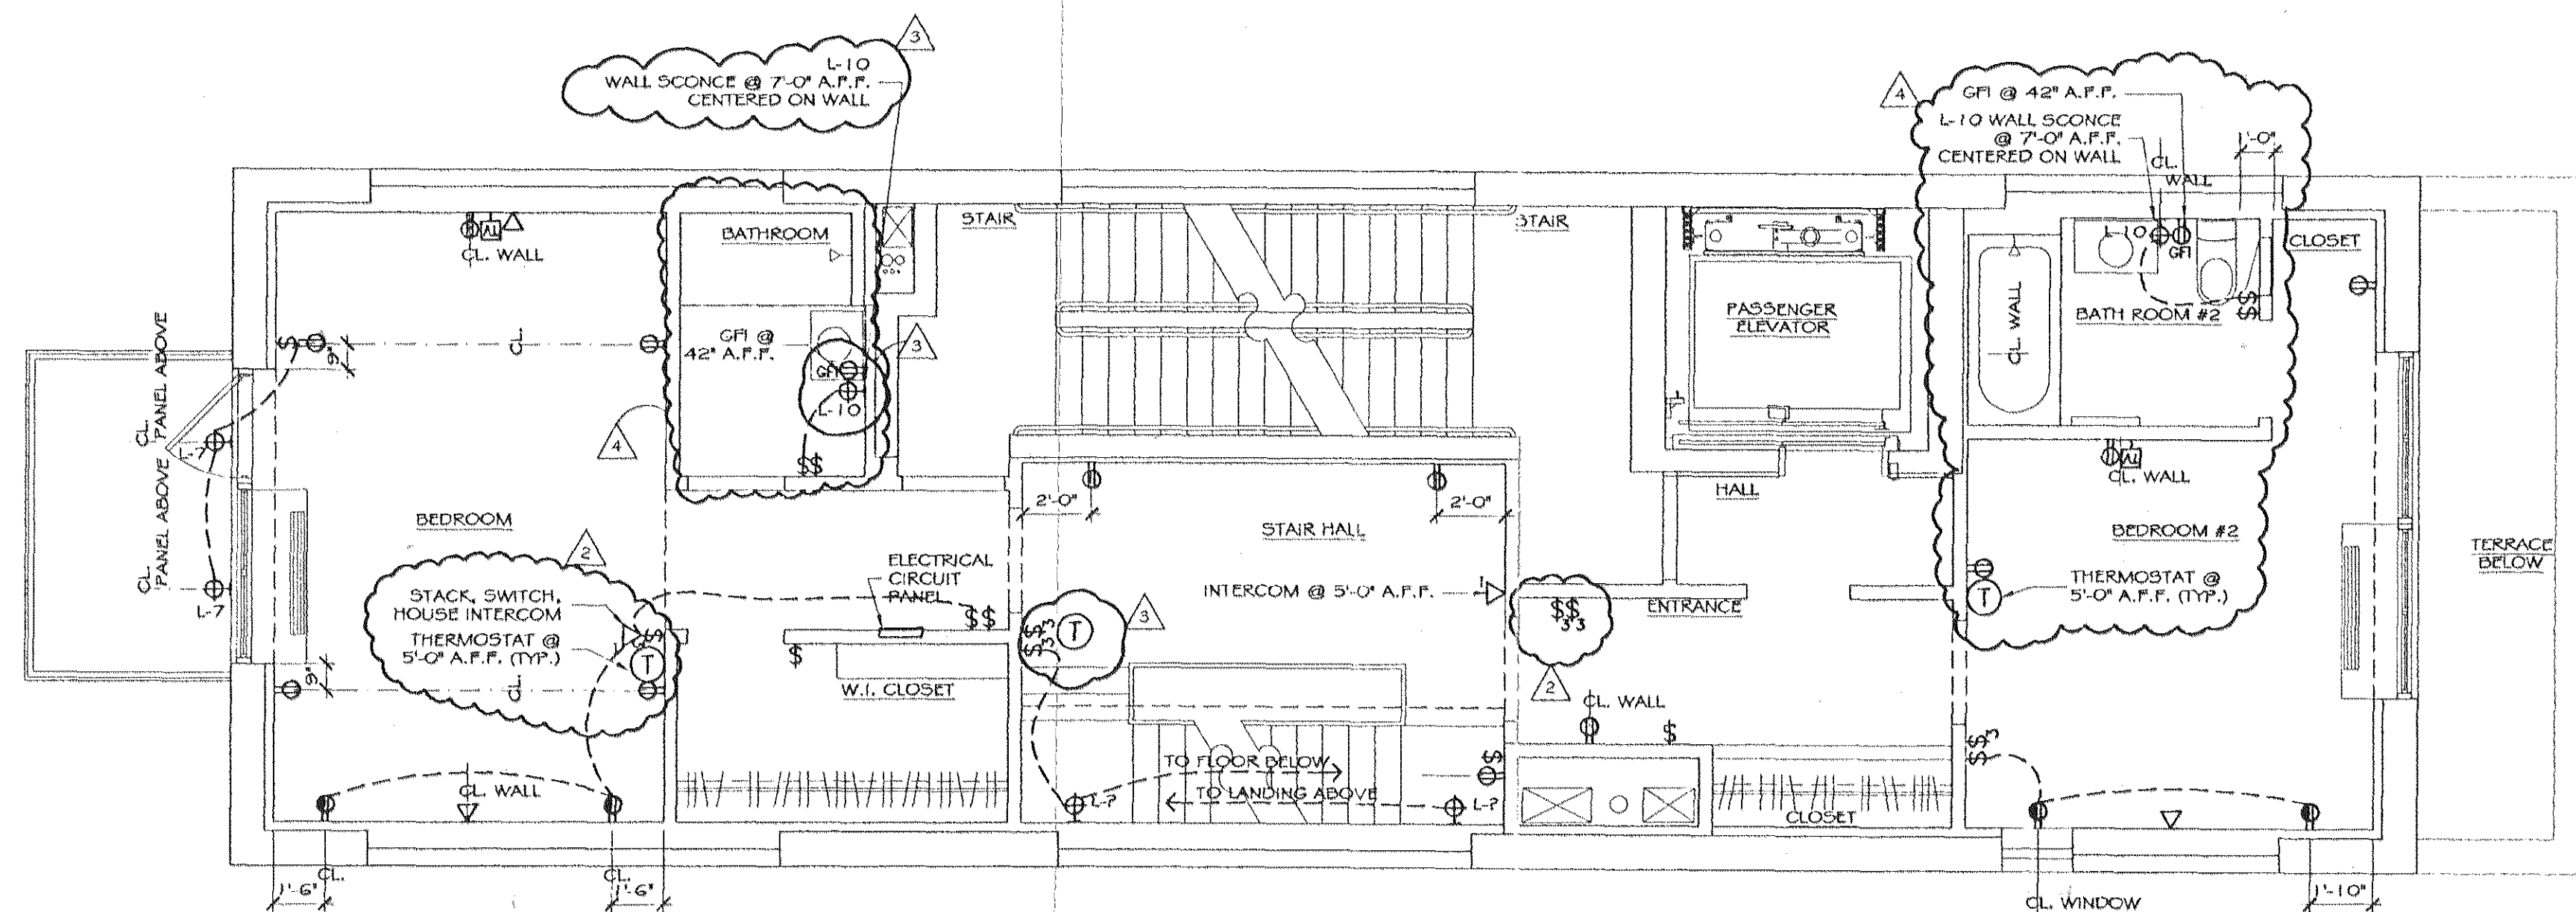

ELECTRICAL PLAN

1/4" = 1'-0"

LEGEND

- OUTLET W/ DEDICATED CIRCUIT @ 12' A.F.F.
- SINGLE OUTLET @ 12' A.F.F., U.O.N.
- DUPLEX OUTLET @ 12' A.F.F., U.O.N.
- GROUND FAULT INTERRUPTER OUTLET @ 12' A.F.F., U.O.N.
- DUPLEX OUTLET HALF HOT @ 12' A.F.F., U.O.N.
- 220 VOLT OUTLET @ 12' A.F.F., U.O.N.
- QUAD OUTLET @ 12' A.F.F., U.O.N.
- FLOOR DUPLEX OUTLET
- FLOOR TELEPHONE JACK
- WALL SWITCH @ 36" A.F.F.
- THREE WAY WALL SWITCH @ 36" A.F.F.
- FOUR WAY WALL SWITCH @ 36" A.F.F.
- JAMB SWITCH @ 8" A.F.F.
- KEYED SWITCH
- SECURITY CARD READER
- THERMOSTAT @ 5'-0" A.F.F.
- TELEPHONE / DATA JACK @ 12' A.F.F.
- HOUSE PHONE INTERCOM @ 5'-0" A.F.F.
- SECURITY CAMERA
- HANDICAP DOOR ACTUATOR
- CABLE JACK @ 12' A.F.F.
- STRIP LIGHT
- WALL SCONCE @ 5'-0" A.F.F.
- JUNCTION BOX
- SPRINKLER
- 18" DIA. SURFACE MOUNTED FLUORESCENT LIGHT FIXTURE
- 18" DIA. SURFACE MOUNTED FLUORESCENT W/ EMERGENCY BATTERY PACK
- RECESSED LIGHT FIXTURE
- DIRECTIONAL LIGHT FIXTURE
- SMOKE DETECTOR
- CARBON MONOXIDE DETECTOR
- EXIT LIGHT
- EMERGENCY BATTERY POWERED LIGHT
- RETURN AIR GRILLE OR EXHAUST
- AIR DIFFUSER
- 22" DIA. SURFACE MOUNTED FLUORESCENT LIGHT FIXTURE
- SURFACE MOUNTED FLUORESCENT LIGHT FIXTURE @ 8'-0" A.F.F. UNLESS OTHER WIRE NOTED
- ACCESS DOOR

- 4 REVISION ISSUED FOR CONSTRUCTION 09/20/07
- 3 REVISION ISSUED FOR CONSTRUCTION 02/01/07
- ISSUED FOR CONSTRUCTION 12/01/06
- 2 ISSUED FOR CONSTRUCTION 11/17/06
- ISSUED FOR PRICING 07/26/06

No.	Revision/Issue	Date
The Deuce 50 W 42nd Street New York NY 10036		
ELECTRICAL & LIGHTING PLAN NINTH FLOOR		
Scale	1/4" = 1'-0"	Sheet No.
Date	07.26.06	E-207
Drawn By	CCC	

RECEIVED
SEP 21 2007
BFI CONSTRUCTION